


NUMBER
RP A2 MTL RVT
 BOARD - SUB-CONSTRUCTION
 A2 boards >8 mm - Metal with rivets
 SECTION - DETAIL
Front Page - Overview
 DESCRIPTION
 Details overview

DATE - VERSION
 01.01.2025
 SCALE - PAPER
 Scale 1:20 on A3 print

LANGUAGE
 All
 PAGE - NUMBER
 Page 01/10



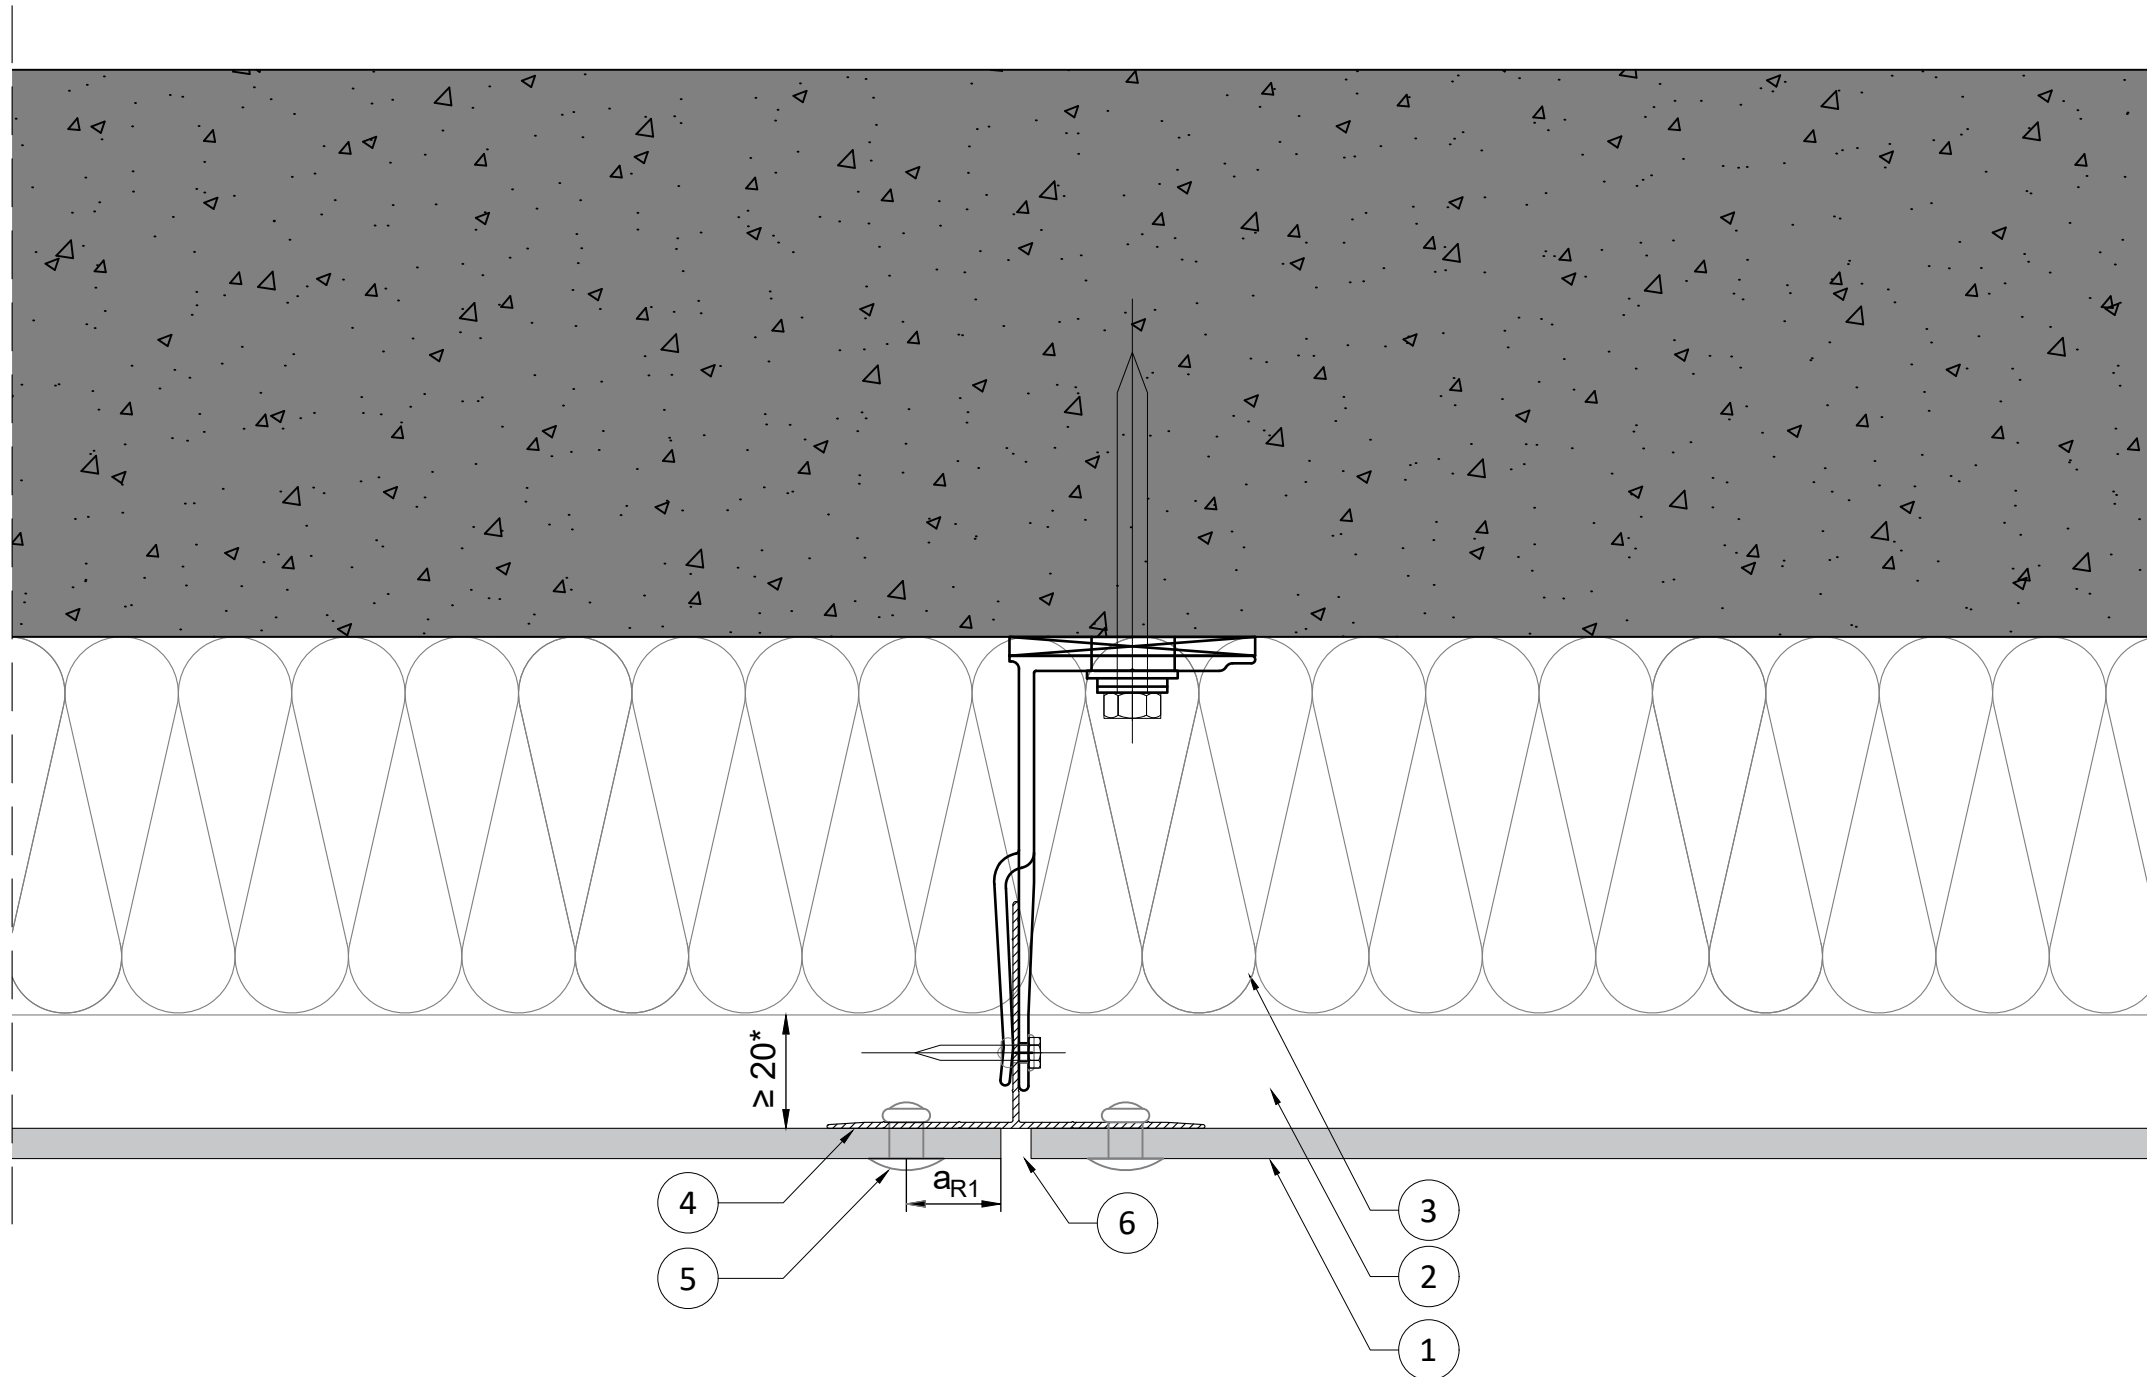


NUMBER
RP A2 MTL RVT - H.01

BOARD - SUB-CONSTRUCTION
A2 boards >8 mm - Metal with rivets
 SECTION - DETAIL
Horizontal section - Detail 01
 DESCRIPTION
Junction vertical joint

DATE - VERSION
 01.01.2025
 SCALE - PAPER
 Scale 1:2 on A3 print

LANGUAGE
 All
 PAGE - NUMBER
 Page 02/10



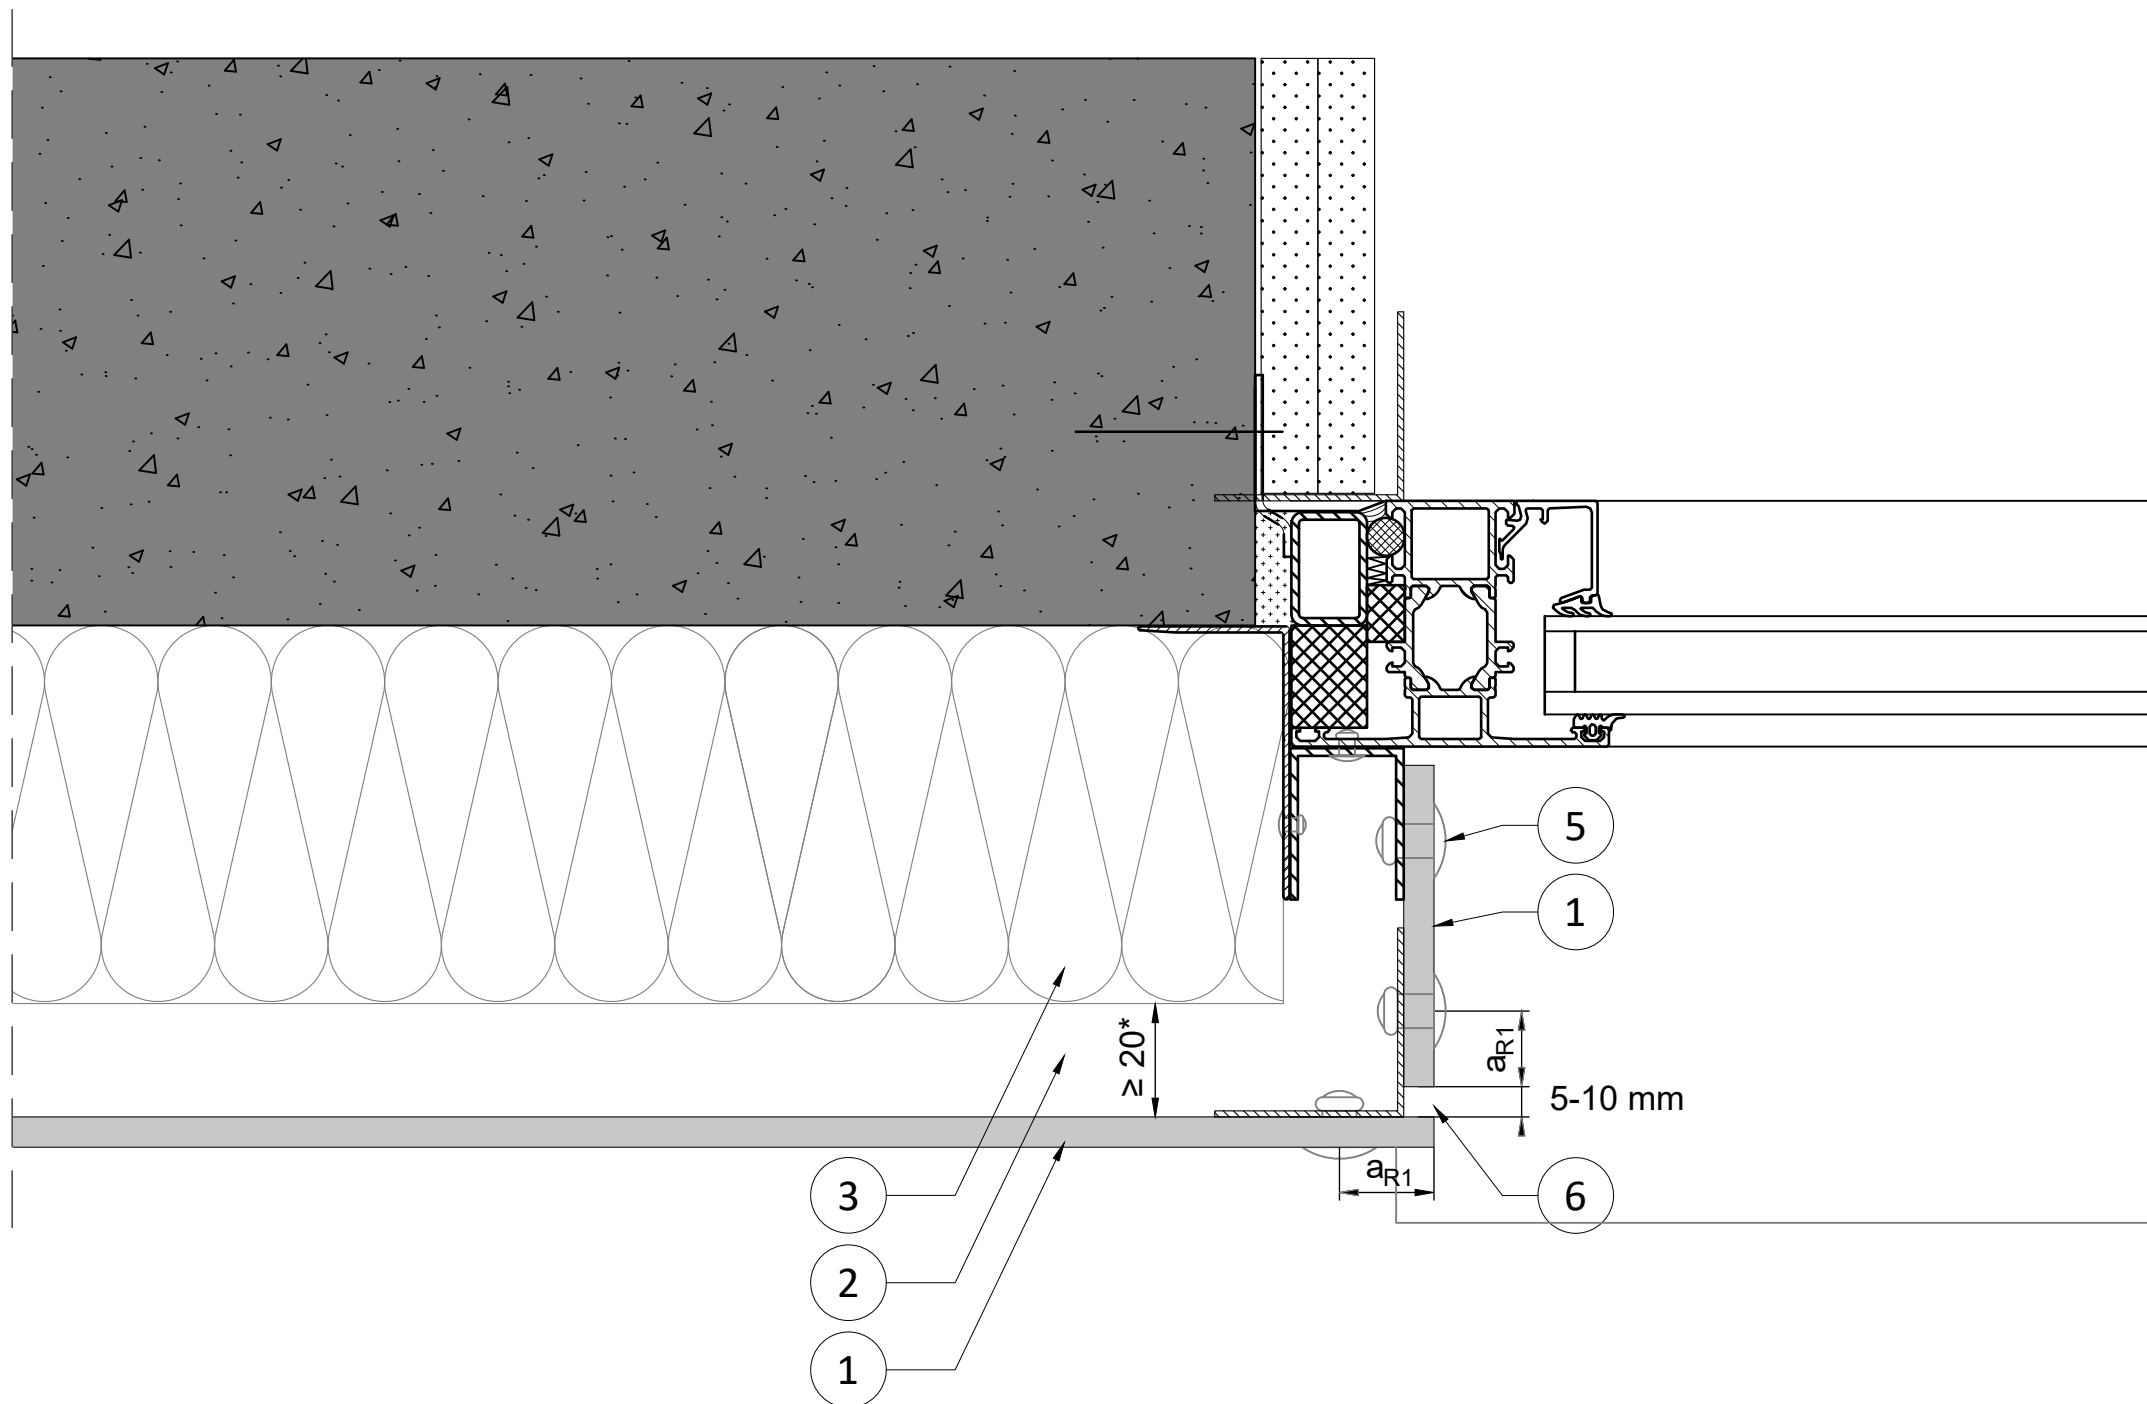


NUMBER
RP A2 MTL RVT - H.02

BOARD - SUB-CONSTRUCTION
A2 boards >8 mm - Metal with rivets
 SECTION - DETAIL
Horizontal section - Detail 02
 DESCRIPTION
Window junction

DATE - VERSION
 01.01.2025
 SCALE - PAPER
 Scale 1:2 on A3 print

LANGUAGE
 All
 PAGE - NUMBER
 Page 03/10

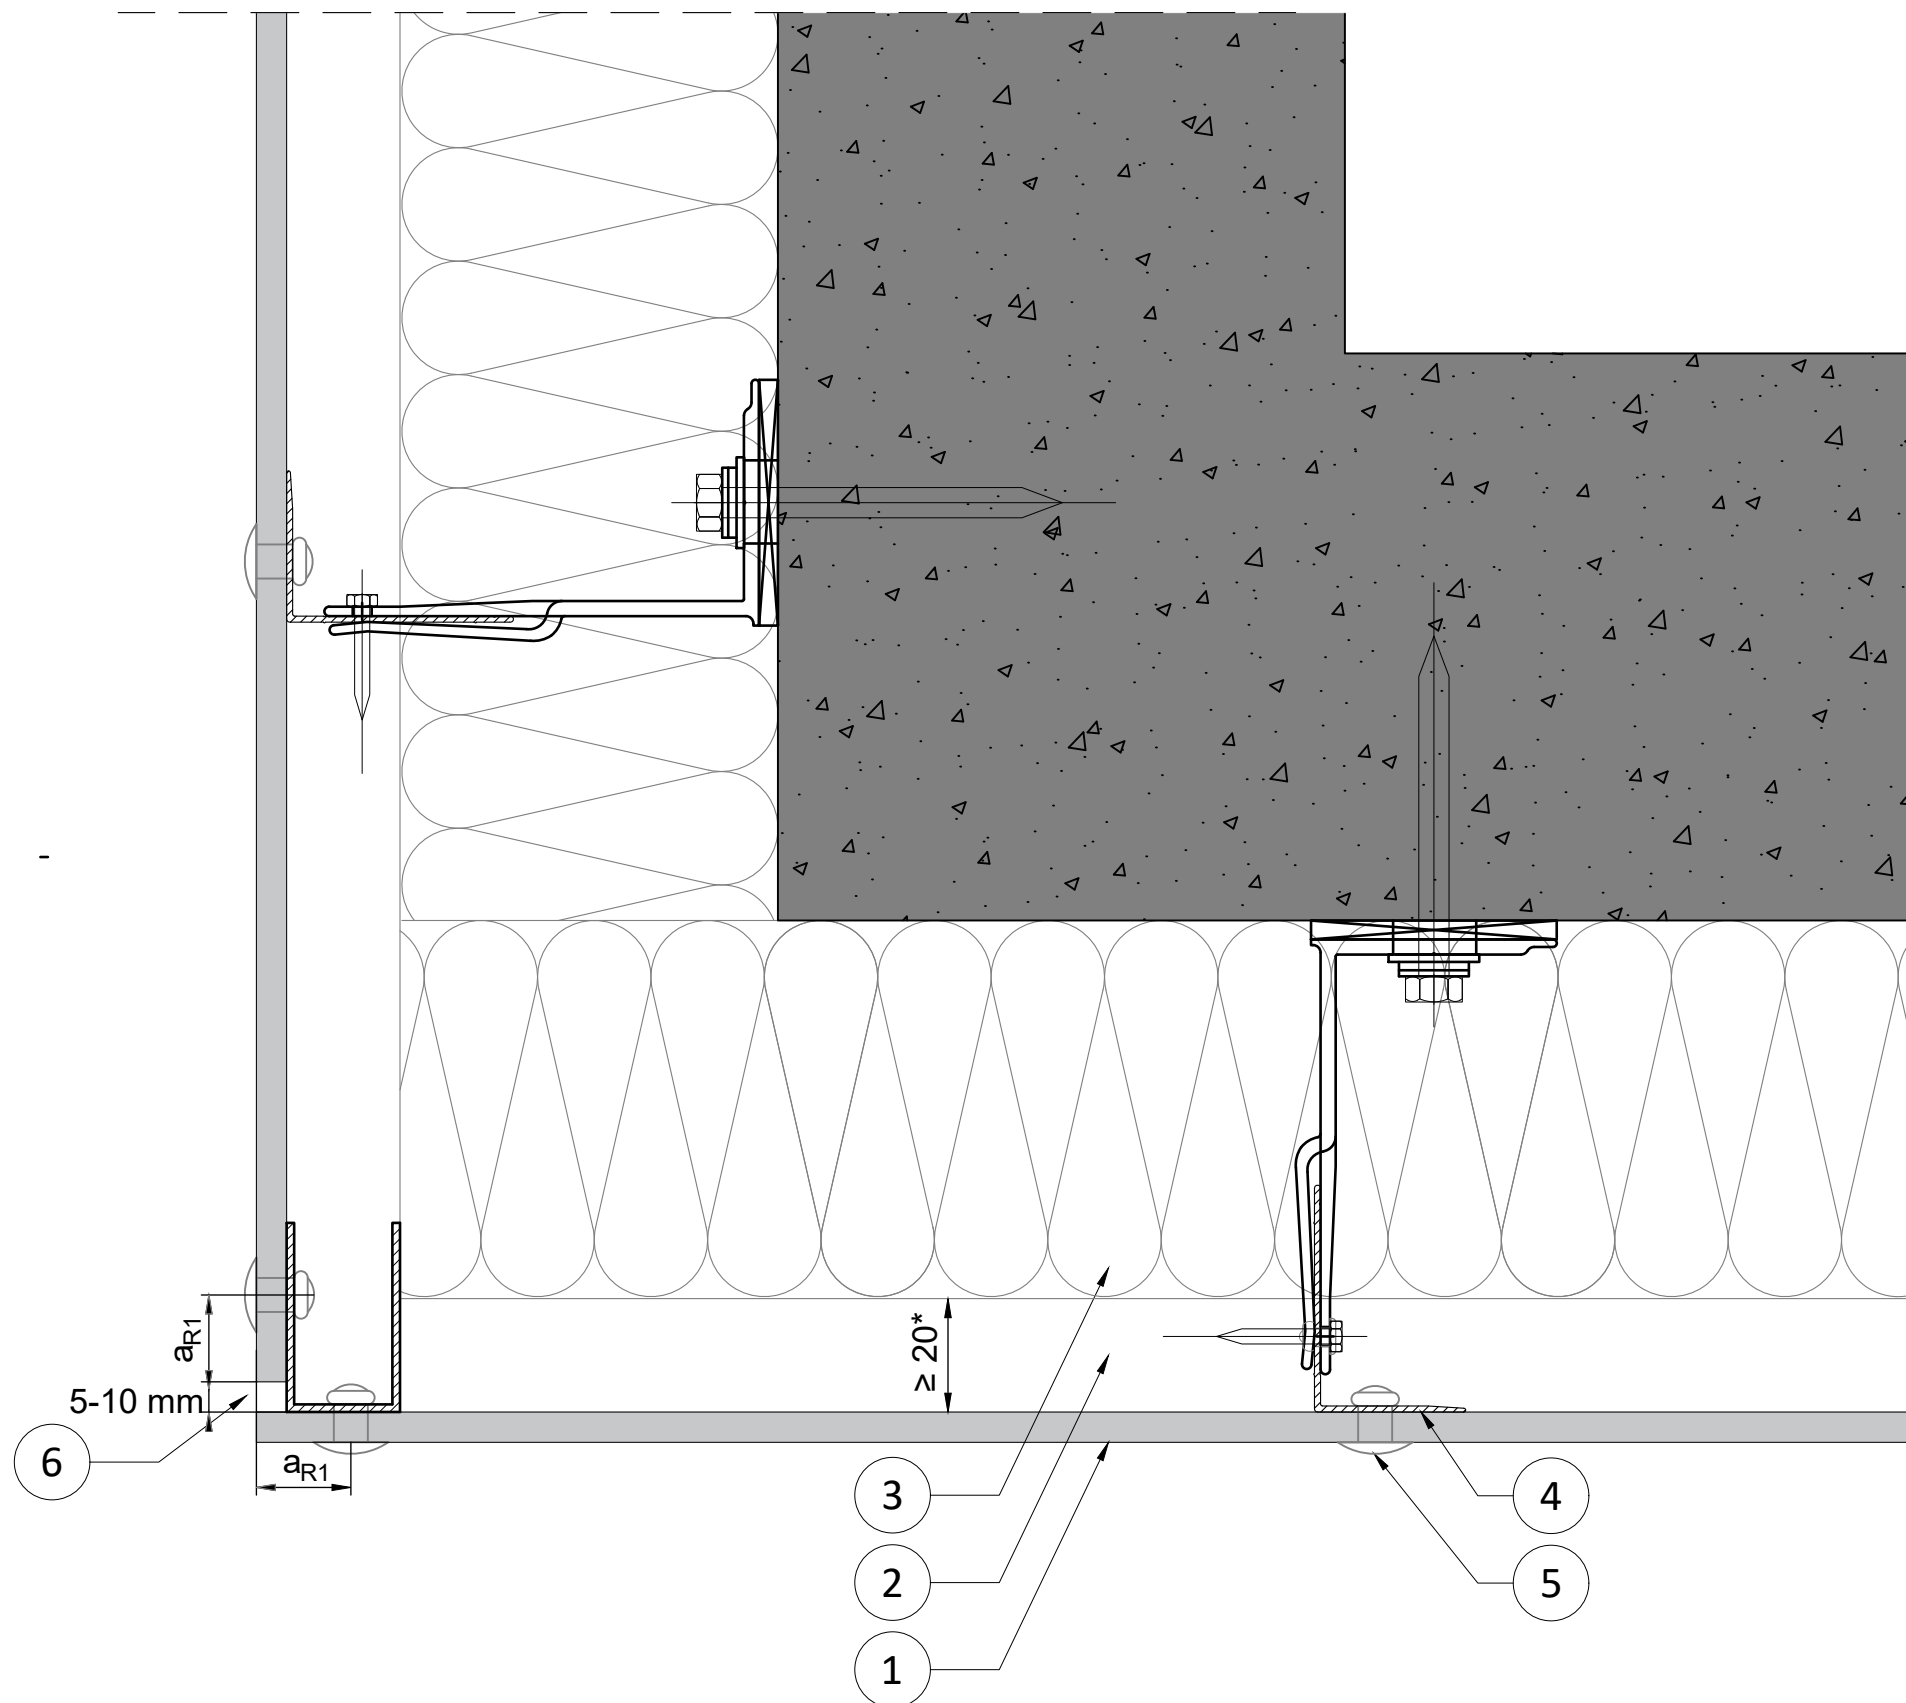


NUMBER
RP A2 MTL RVT - H.03

BOARD - SUB-CONSTRUCTION
A2 boards >8 mm - Metal with rivets
 SECTION - DETAIL
Horizontal section - Detail 03
 DESCRIPTION
Junction vertical joint

DATE - VERSION
 01.01.2025
 SCALE - PAPER
 Scale 1:2 on A3 print

LANGUAGE
 All
 PAGE - NUMBER
 Page 04/10



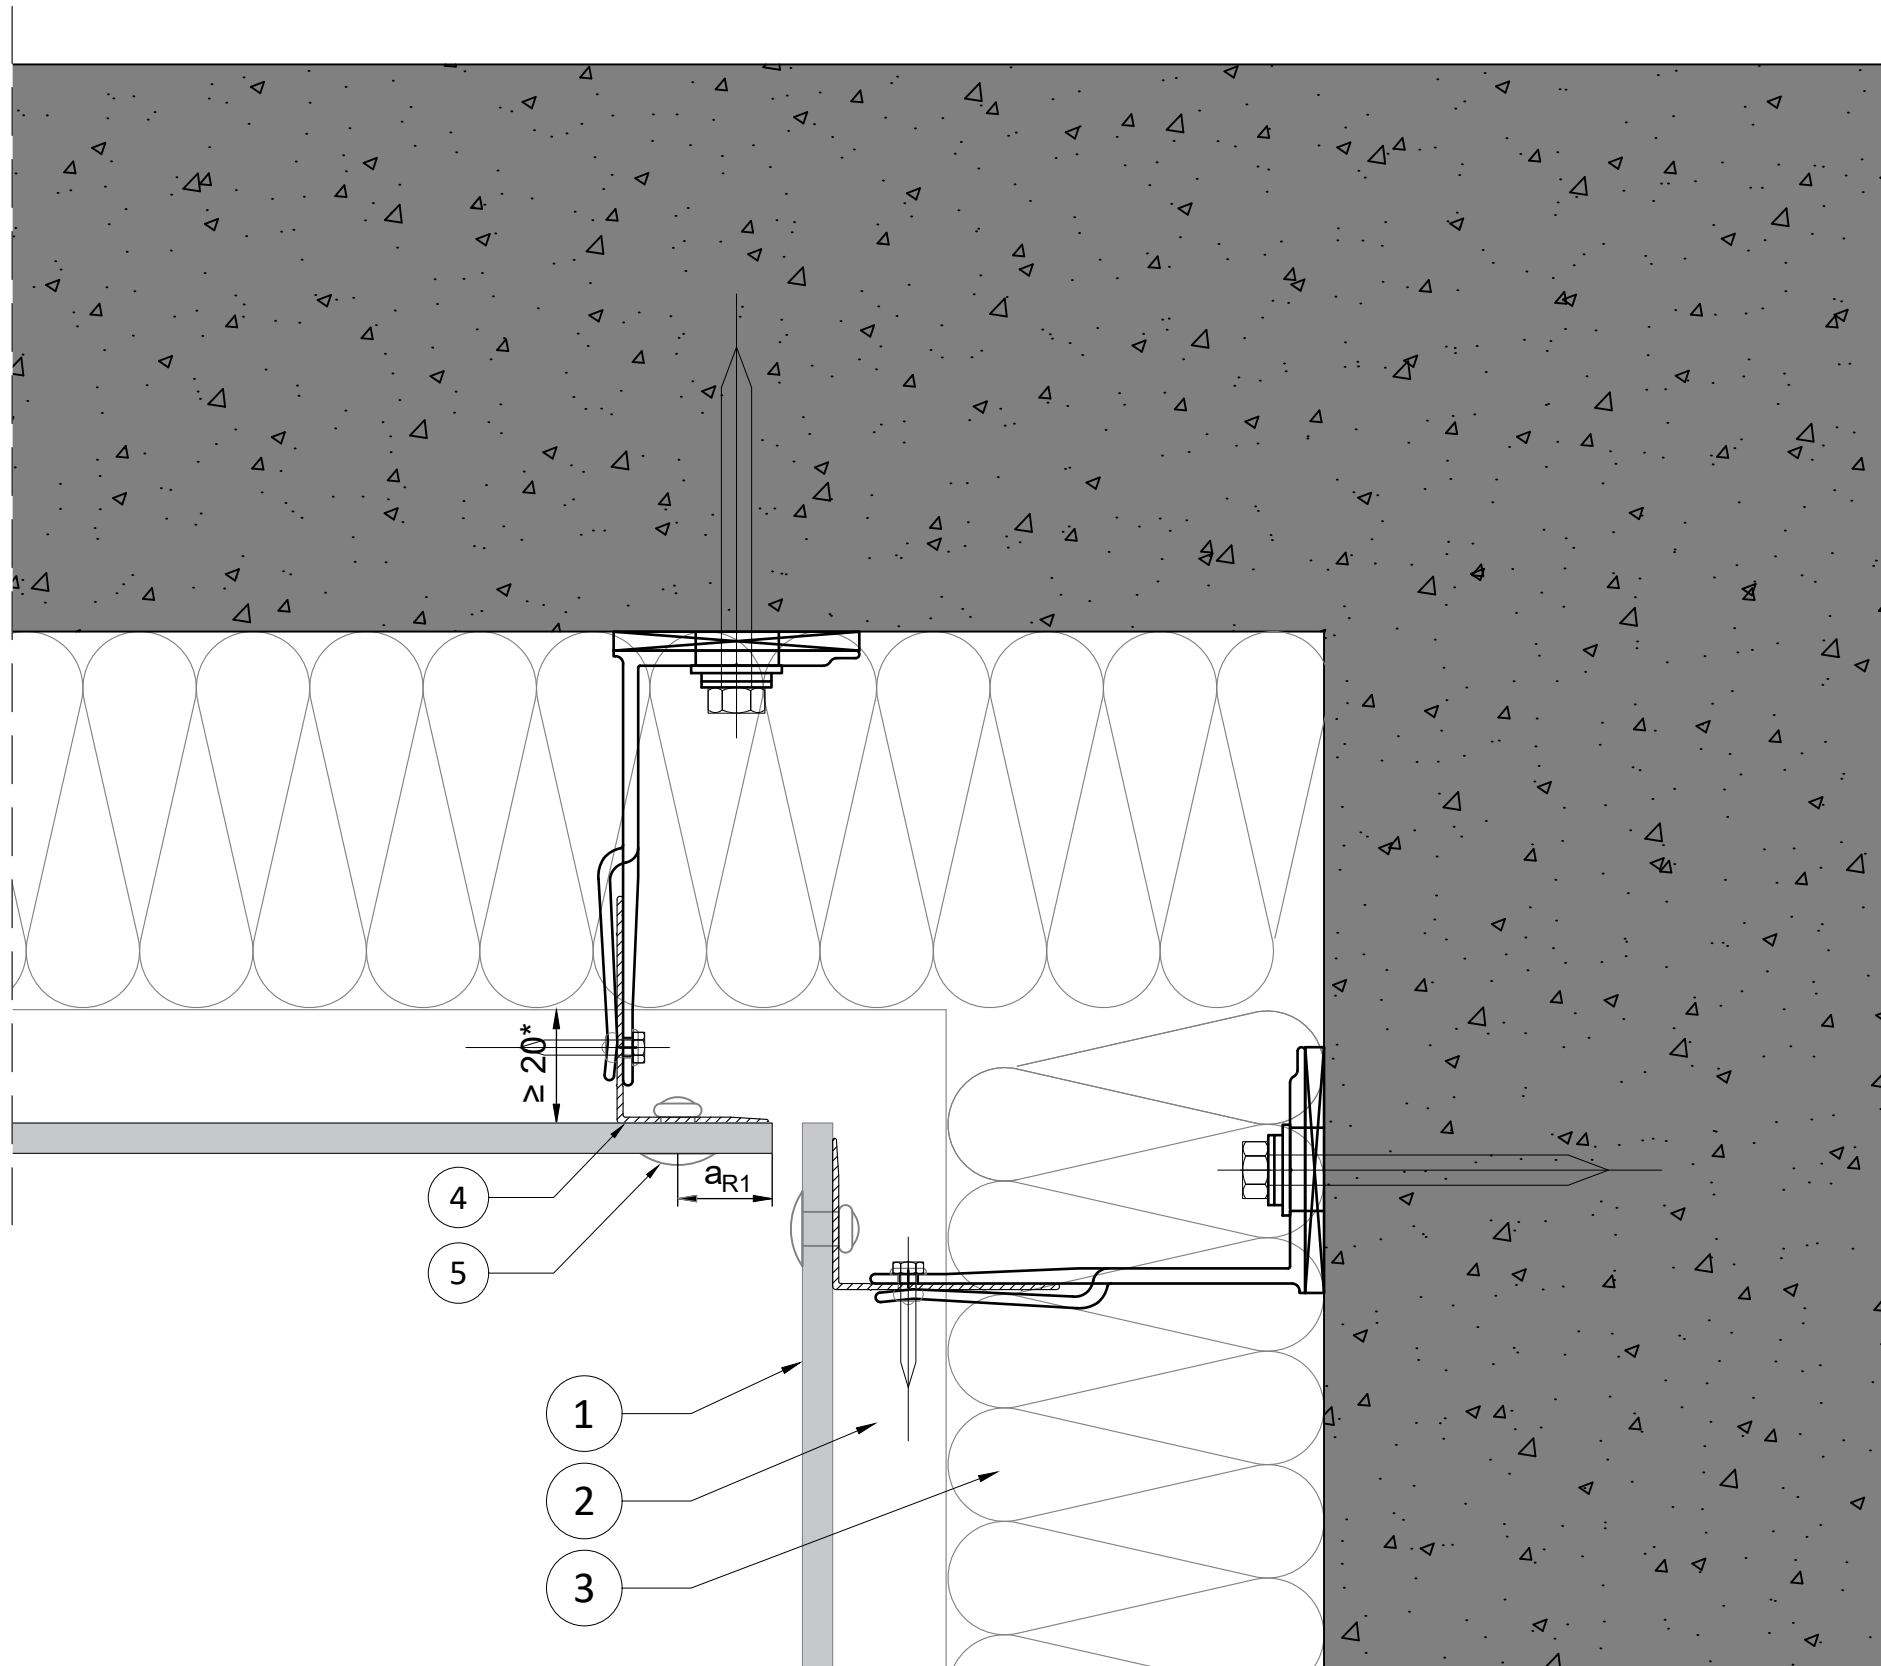


NUMBER
RP A2 MTL RVT - H.04

BOARD - SUB-CONSTRUCTION
A2 boards >8 mm - Metal with rivets
 SECTION - DETAIL
Horizontal section - Detail 04
 DESCRIPTION
Internal Corner

DATE - VERSION
 01.01.2025
 SCALE - PAPER
 Scale 1:2 on A3 print

LANGUAGE
 All
 PAGE - NUMBER
 Page 05/10



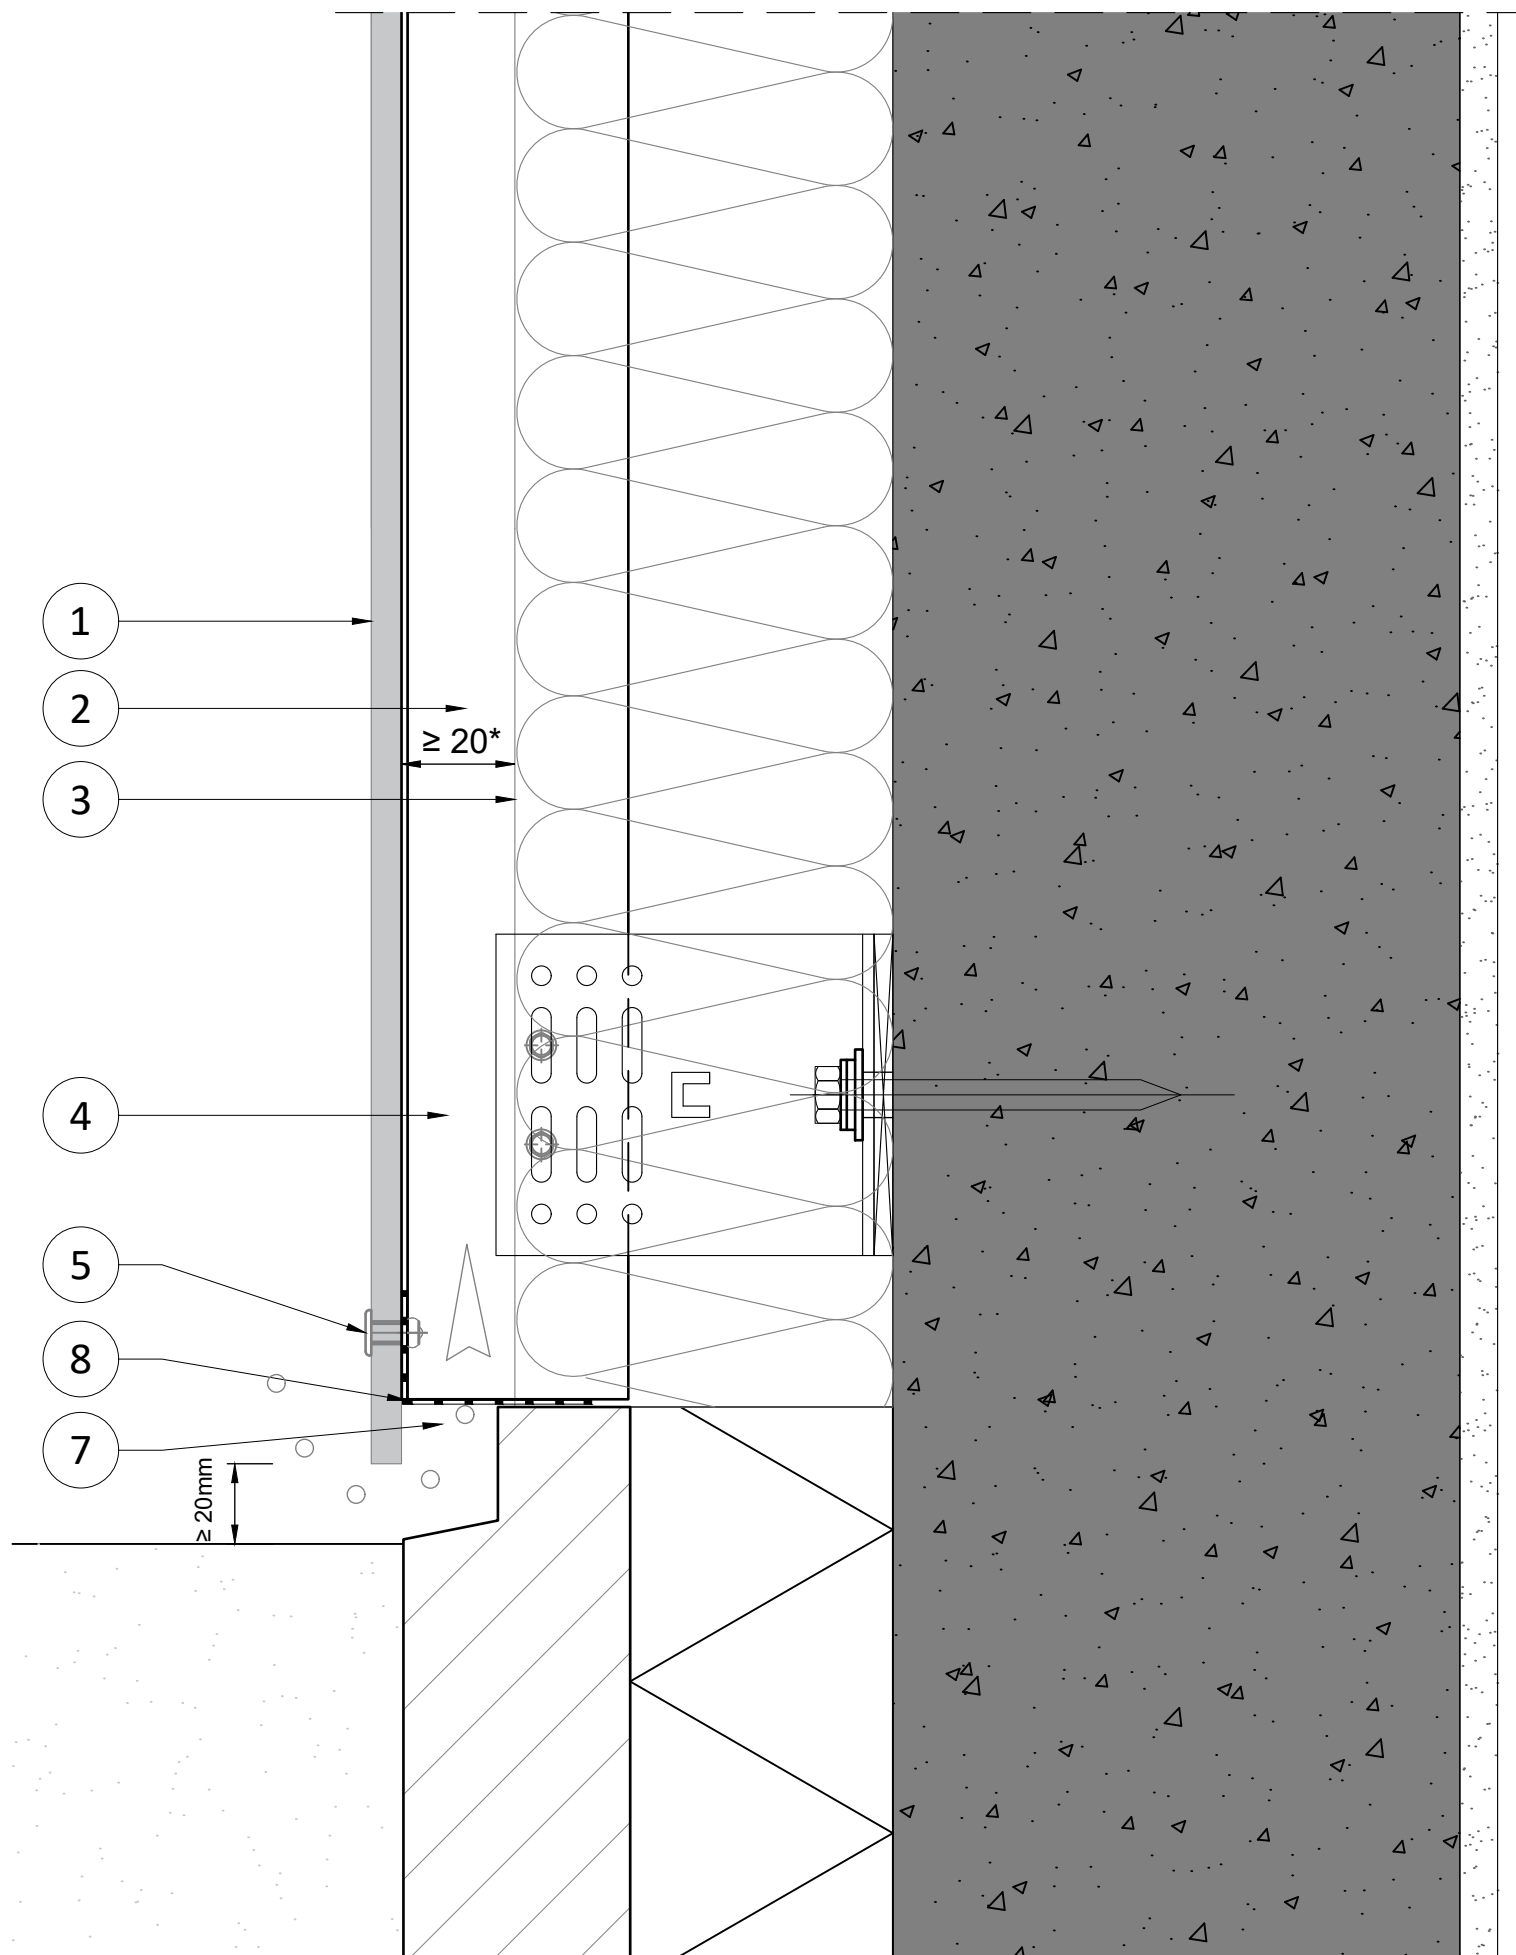

NUMBER
RP A2 MTL RVT - V.01

BOARD - SUB-CONSTRUCTION
A2 boards >8 mm - Metal with rivets

SECTION - DETAIL
Vertical section - Detail 01


DESCRIPTION
Junction vertical joint

DATE - VERSION
 01.01.2025

SCALE - PAPER
 Scale 1:2 on A3 print

LANGUAGE
 All
 PAGE - NUMBER
 Page 06/10



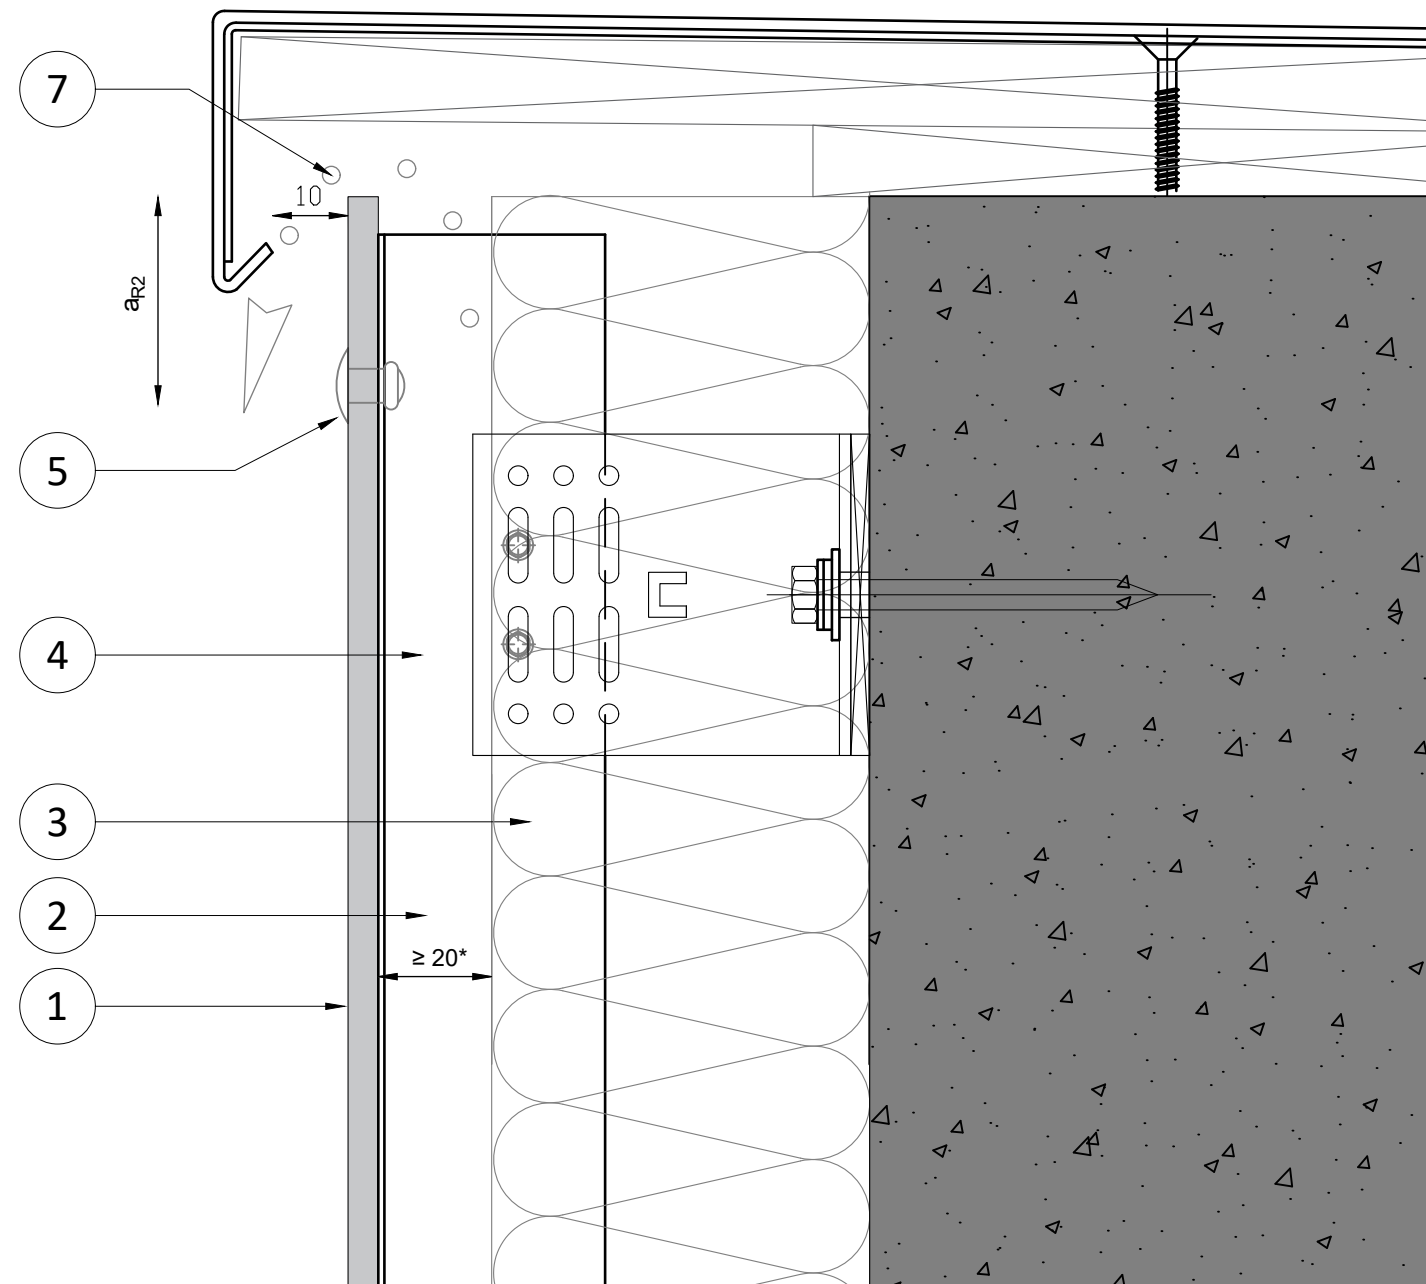


NUMBER
RP A2 MTL RVT - V.02

BOARD - SUB-CONSTRUCTION
A2 boards >8 mm - Metal with rivets
 SECTION - DETAIL
Vertical section - Detail 02
 DESCRIPTION
Roof trim - parapet

DATE - VERSION
 01.01.2025
 SCALE - PAPER
 Scale 1:2 on A3 print

LANGUAGE
 All
 PAGE - NUMBER
 Page 07/10



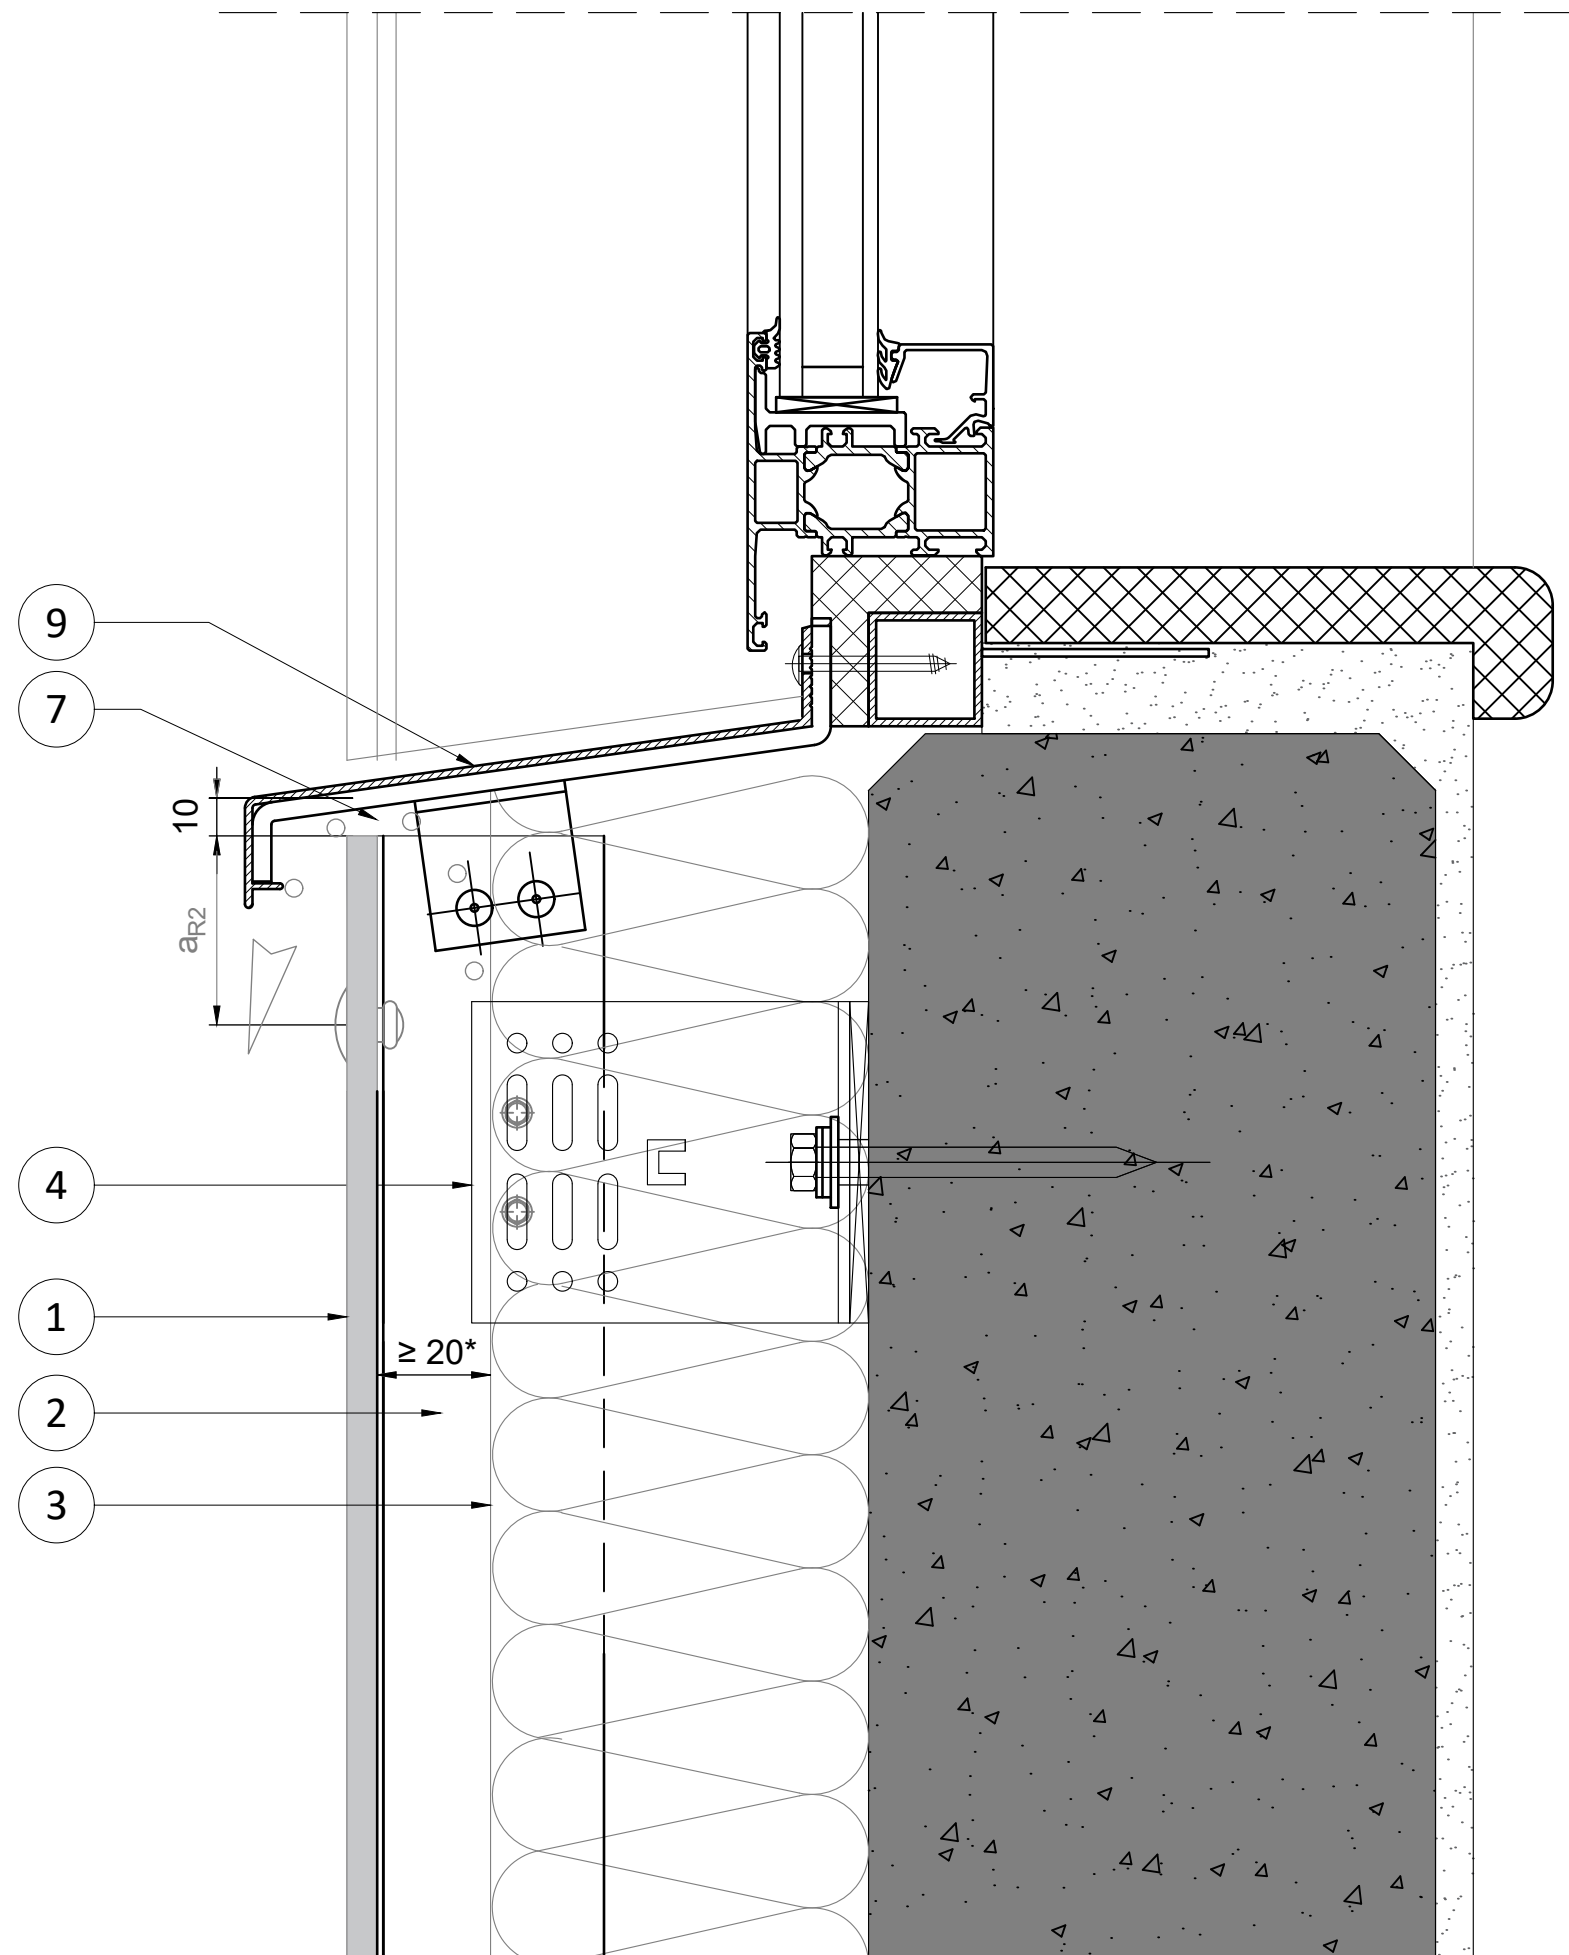

NUMBER
RP A2 MTL RVT - V.03

BOARD - SUB-CONSTRUCTION
A2 boards >8 mm - Metal with rivets


SECTION - DETAIL
Vertical section - Detail 03

DESCRIPTION
Junction window-sill

DATE - VERSION
 01.01.2025
 SCALE - PAPER
 Scale 1:2 on A3 print

LANGUAGE
 All
 PAGE - NUMBER
 Page 08/10



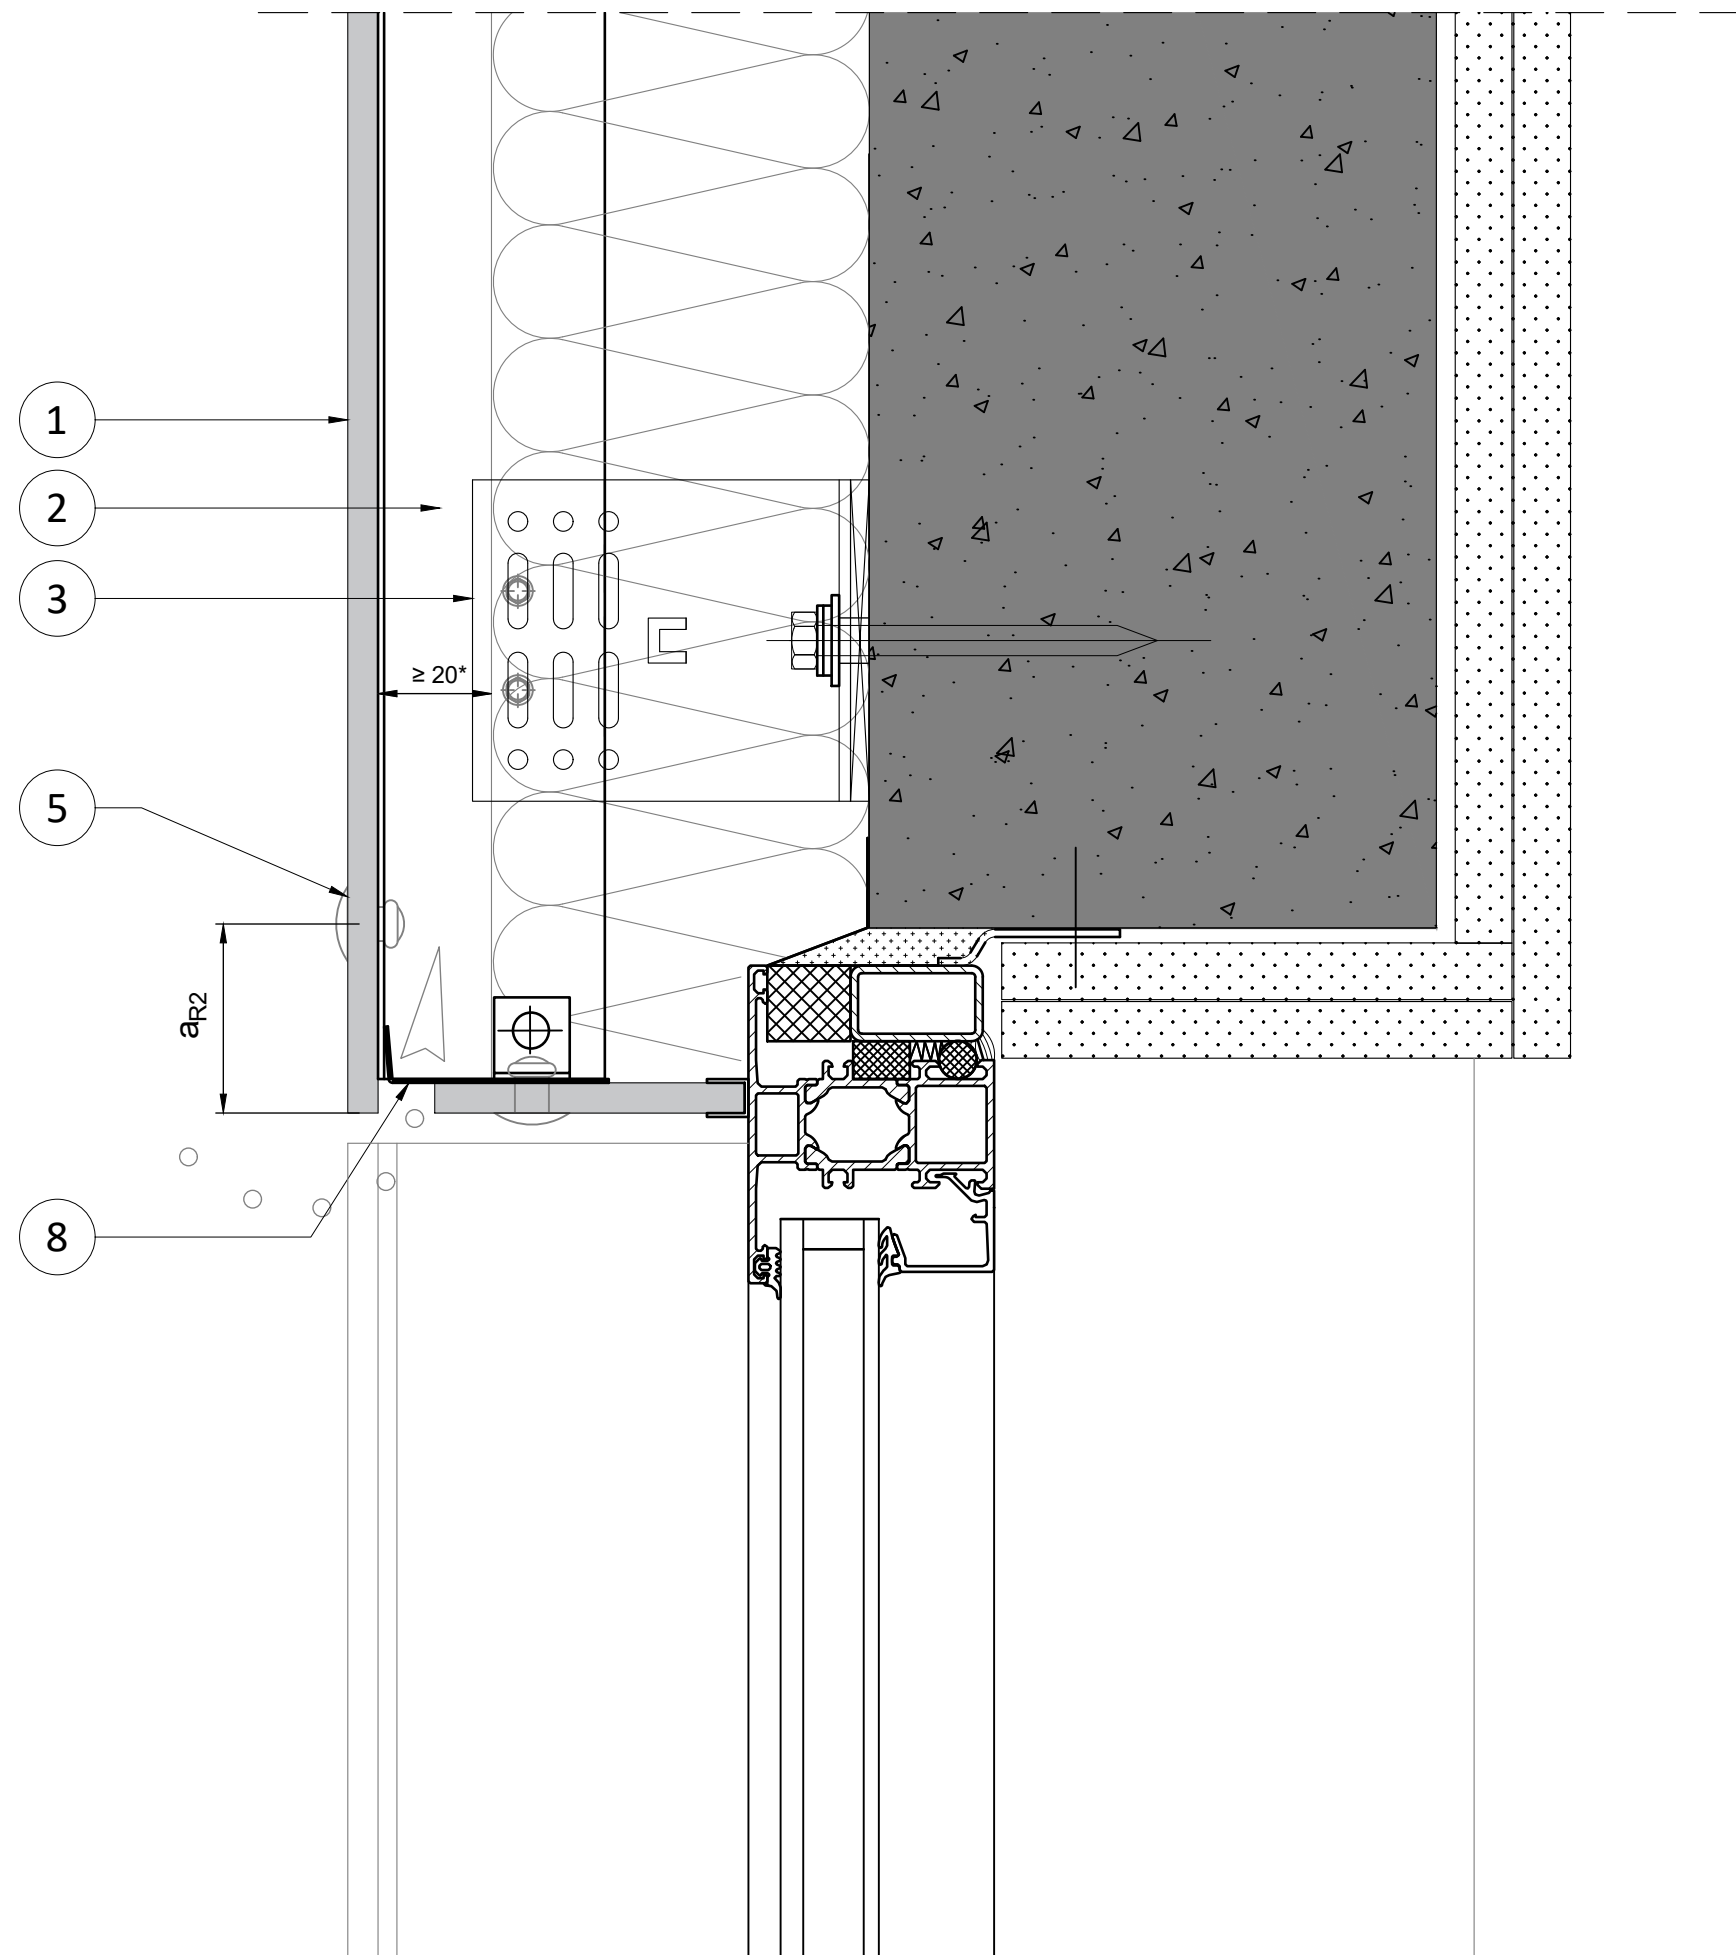

NUMBER
RP A2 MTL RVT - V04

BOARD - SUB-CONSTRUCTION
A2 boards >8 mm - Metal with rivets
 SECTION - DETAIL
Vertical section - Detail 03
 DESCRIPTION
Junction window header

DATE - VERSION
 01.01.2025
 SCALE - PAPER
 Scale 1:2 on A3 print

LANGUAGE
 All
 PAGE - NUMBER
 Page 09/10



	EN	NL	DE	FR	PL
1	Rockpanel A2 board \geq 8mm	Rockpanel A2 8mm	Rockpanel A2 8mm	Rockpanel A2 8mm	Rockpanel A2 8mm
2	Air cavity	Luchtspouw	Hinterlüftungsraum	Lame d'air	Szczelina wentylacja
3	Insulation (ROCKWOOL)	Steenwolisolatie (ROCKWOOL)	Dämmung (ROCKWOOL)	Isolation (ROCKWOOL)	Izolacja (ROCKWOOL)
4	Aluminium rail	Aluminium draagprofiel	Aluminium Tragprofil	Montant Aluminium	Profil aluminiowy
5	Fixing (rivet / screw)	Bevestiger (popnagel / schroef)	Befestiger (Blindniete / Schraube)	Fixation (rivet / vis)	Łącznik (nit / wkręty)
6	Joint from 5 to 10 mm	Voeg van 5 tot 10 mm	Fuge von 5 bis 10 mm	Joint de 5 à 10 mm	Łączenie od 5 do 10 mm
7	Ventilation opening	Ventilatieopening	Lüftungsspalt	Vide de ventilation	Szczelina wentylacyjna
8	Ventilation profile / Anti-Insect mesh	Ventilatieprofiel (anti-insect)	Lüftungsprofil	Profil de ventilation / Grille anti-rongeur	Profil wentylacyjny / Siatka zabezpieczająca przed owadami
9	Windowsill with end dam	Vensterbank met kopschot	Fensterbank mit kopenteil	Seuil alu avec larmier	Parapet okienny
a _R 1	\geq 20 mm	\geq 20 mm	\geq 20 mm	\geq 20 mm	\geq 20 mm
a _R 2	\geq 50 mm	\geq 50 mm	\geq 50 mm	\geq 50 mm	\geq 50 mm

	EN	DK	NO	SE	FI
1	Rockpanel A2 8 mm	Rockpanel A2 8 mm	Rockpanel A2 8 mm	Rockpanel A2 8 mm	Rockpanel A2 8 mm
2	Air cavity	Ventilation	Luft hulrom	Luftspalt	Tuuletusväli
3	Insulation (ROCKWOOL)	Isolering (ROCKWOOL)	Isolasjon (ROCKWOOL)	Isolering (ROCKWOOL)	Eriste (ROCKWOOL)
4	Aluminium rail	Aluminium opretstående	Aluminium skinne	Aluminiumskena	Alumiiniranka
5	Fixing (rivet / screw)	Fastgørelse (popnitter / skrue)	Feste (nagle / skrue)	Infästning (popnit / skruv)	Kiinnike (niitti / ruuvi)
6	Joint from 5 to 10 mm	Samling fra 5 til 10 mm	Skjøtene (5-10 mm)	Fog från 5 till 10 mm	Sauma 5-10 mm
7	Ventilation opening	Ventilation	Ventilasjonsåpning	Ventilationsöppning	Tuuletusvälin suuaukko
8	Ventilation profile / Anti-Insect mesh	Ventilations profil / Insektnet	Ventilasjonsprofil / Insektsnett	Ventilationsprofil / Insektsskydd	Tuuletusprofiili / Hyönteisverkko
9	Windowsill with end dam	Sålbænk	Vinduskarm med kant	Fönsterbleck med sidokant	Ikkunan vesipelti
a _R 1	\geq 20 mm	\geq 20 mm	\geq 20 mm	\geq 20 mm	\geq 20 mm
a _R 2	\geq 50 mm	\geq 50 mm	\geq 50 mm	\geq 50 mm	\geq 50 mm

NUMBER
RP A2 8 MTL RVT

BOARD - SUB-CONSTRUCTION
A2 8 mm - Aluminium with rivets
SECTION - DETAIL
Descriptions and Translations

