


NUMBER
RP A2 11 MSF
 BOARD - SUB-CONSTRUCTION
Premium A2 11 mm - Mechanical Secret Fix
 SECTION - DETAIL
Front Page - Overview
 DESCRIPTION
Details overview

DATE - VERSION
 01.01.2025
 SCALE - PAPER
 Scale 1:20 on A3 print

LANGUAGE
 All
 PAGE - NUMBER
 Page 01/10



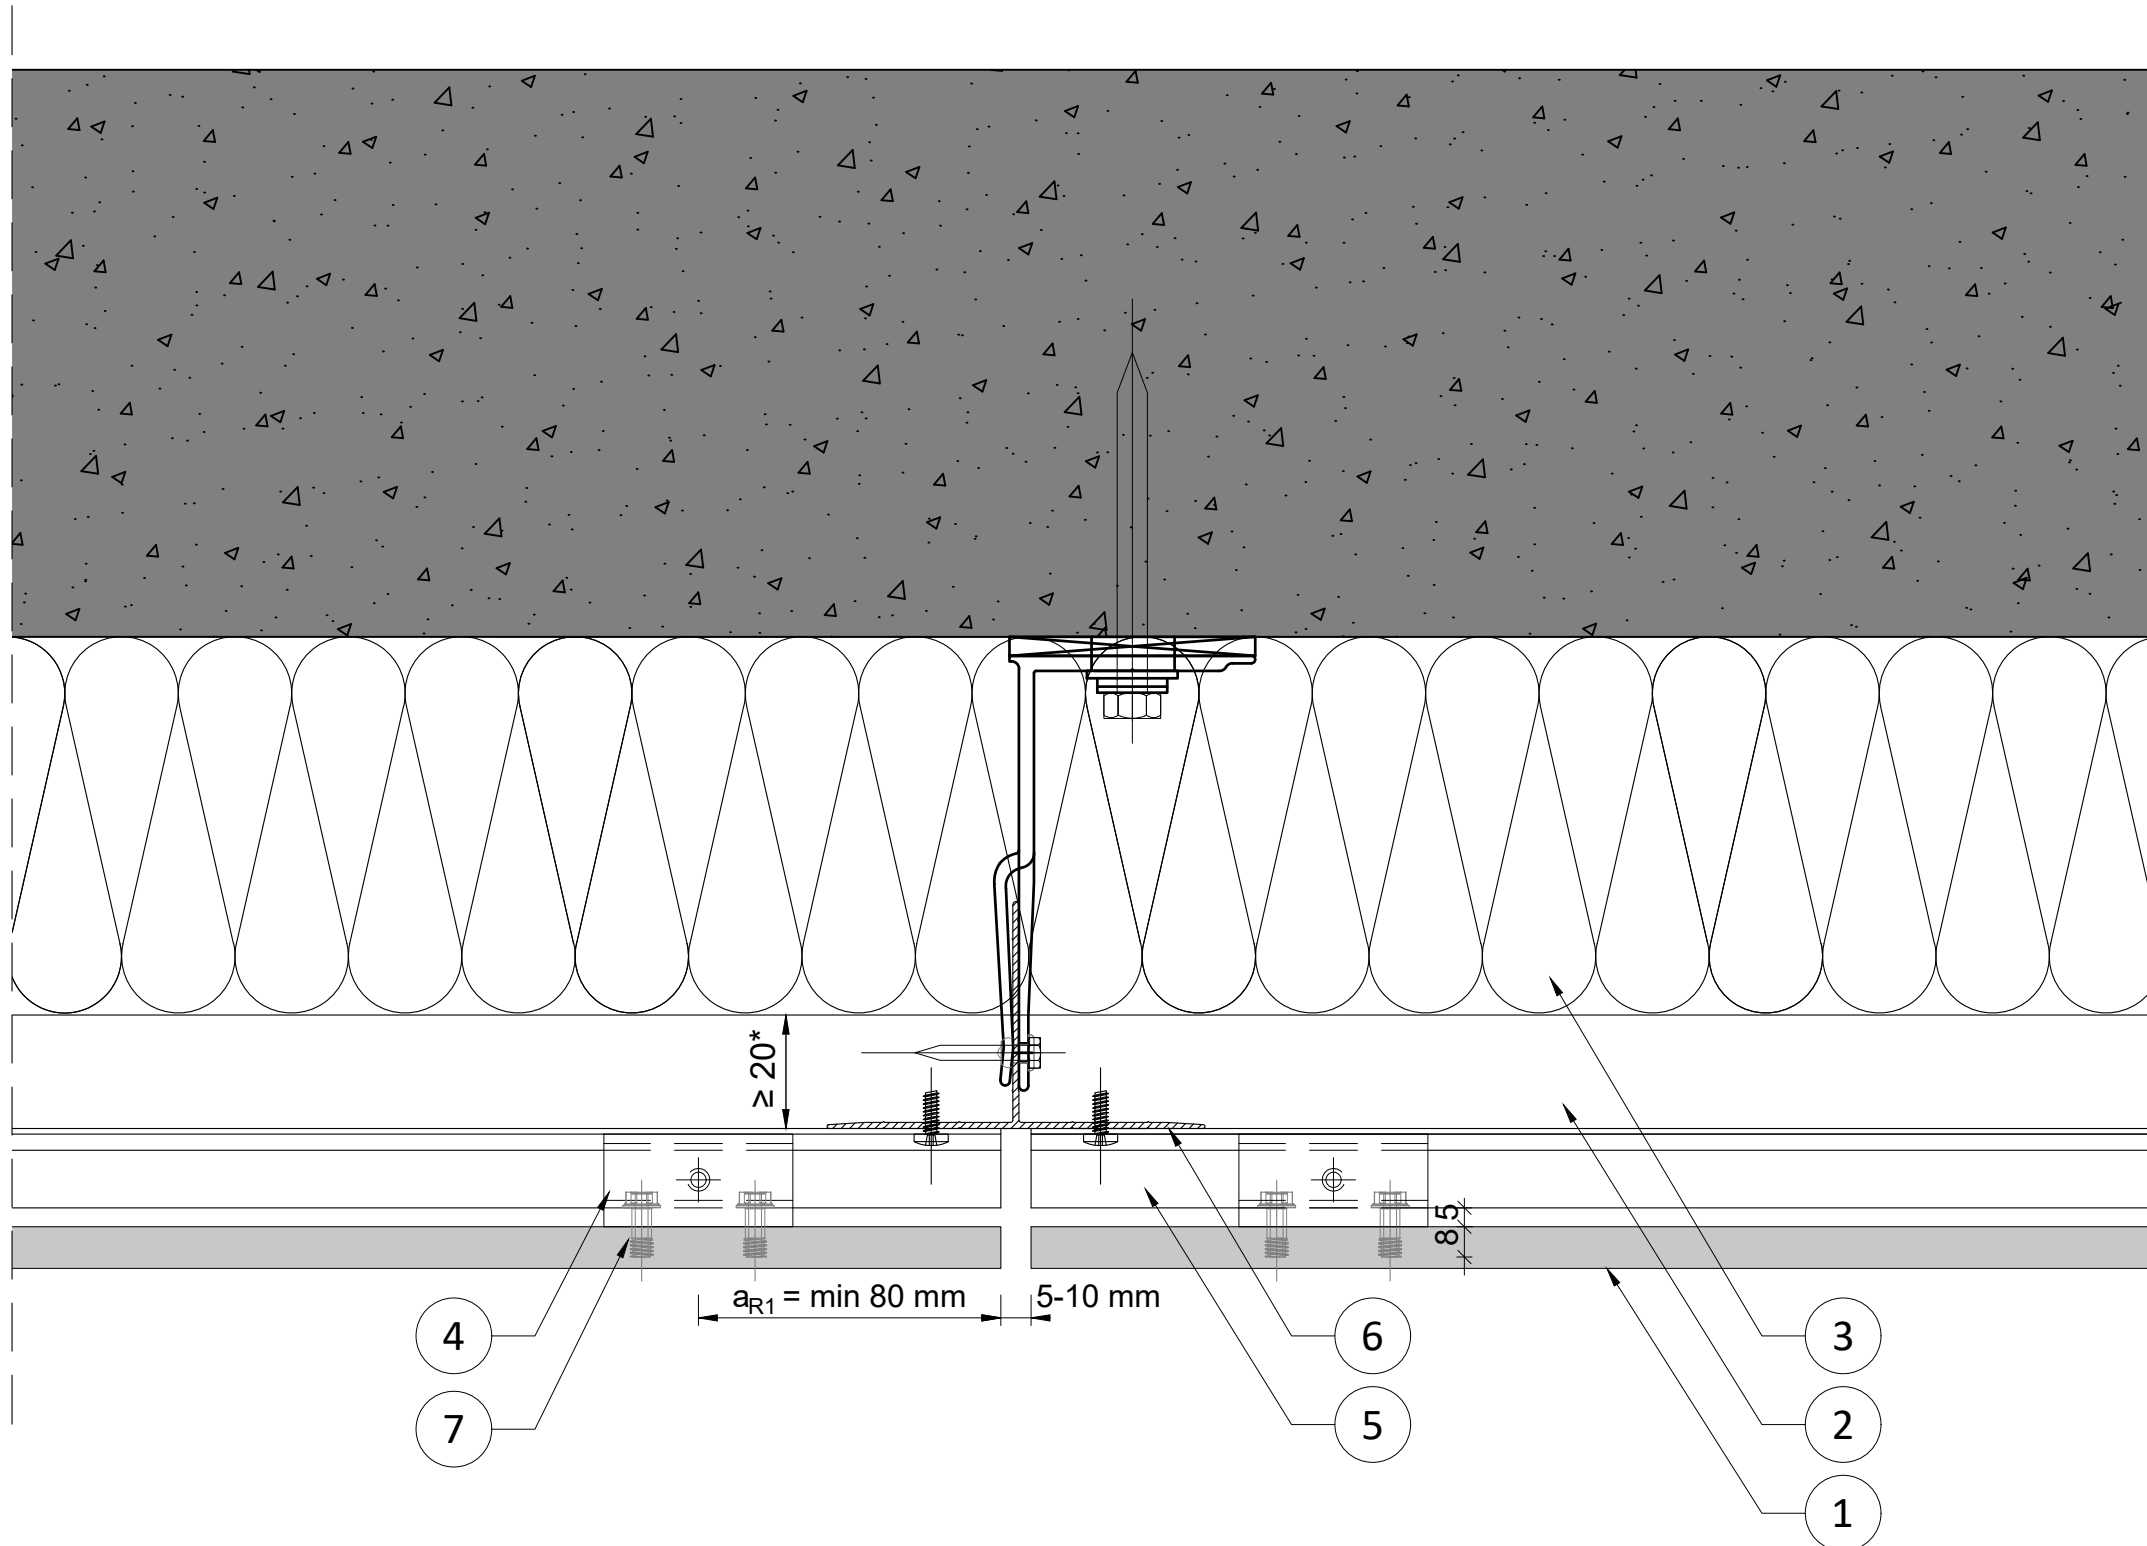


NUMBER
RP A2 11 MSF - H.01
 BOARD - SUB-CONSTRUCTION
Premium A2 11 mm - Mechanical Secret Fix
 SECTION - DETAIL
Horizontal section - Detail 01
 DESCRIPTION
Junction vertical joint

DATE - VERSION
 01.01.2025
 SCALE - PAPER
 Scale 1:2 on A3 print

LANGUAGE
 All
 PAGE - NUMBER
 Page 02/10



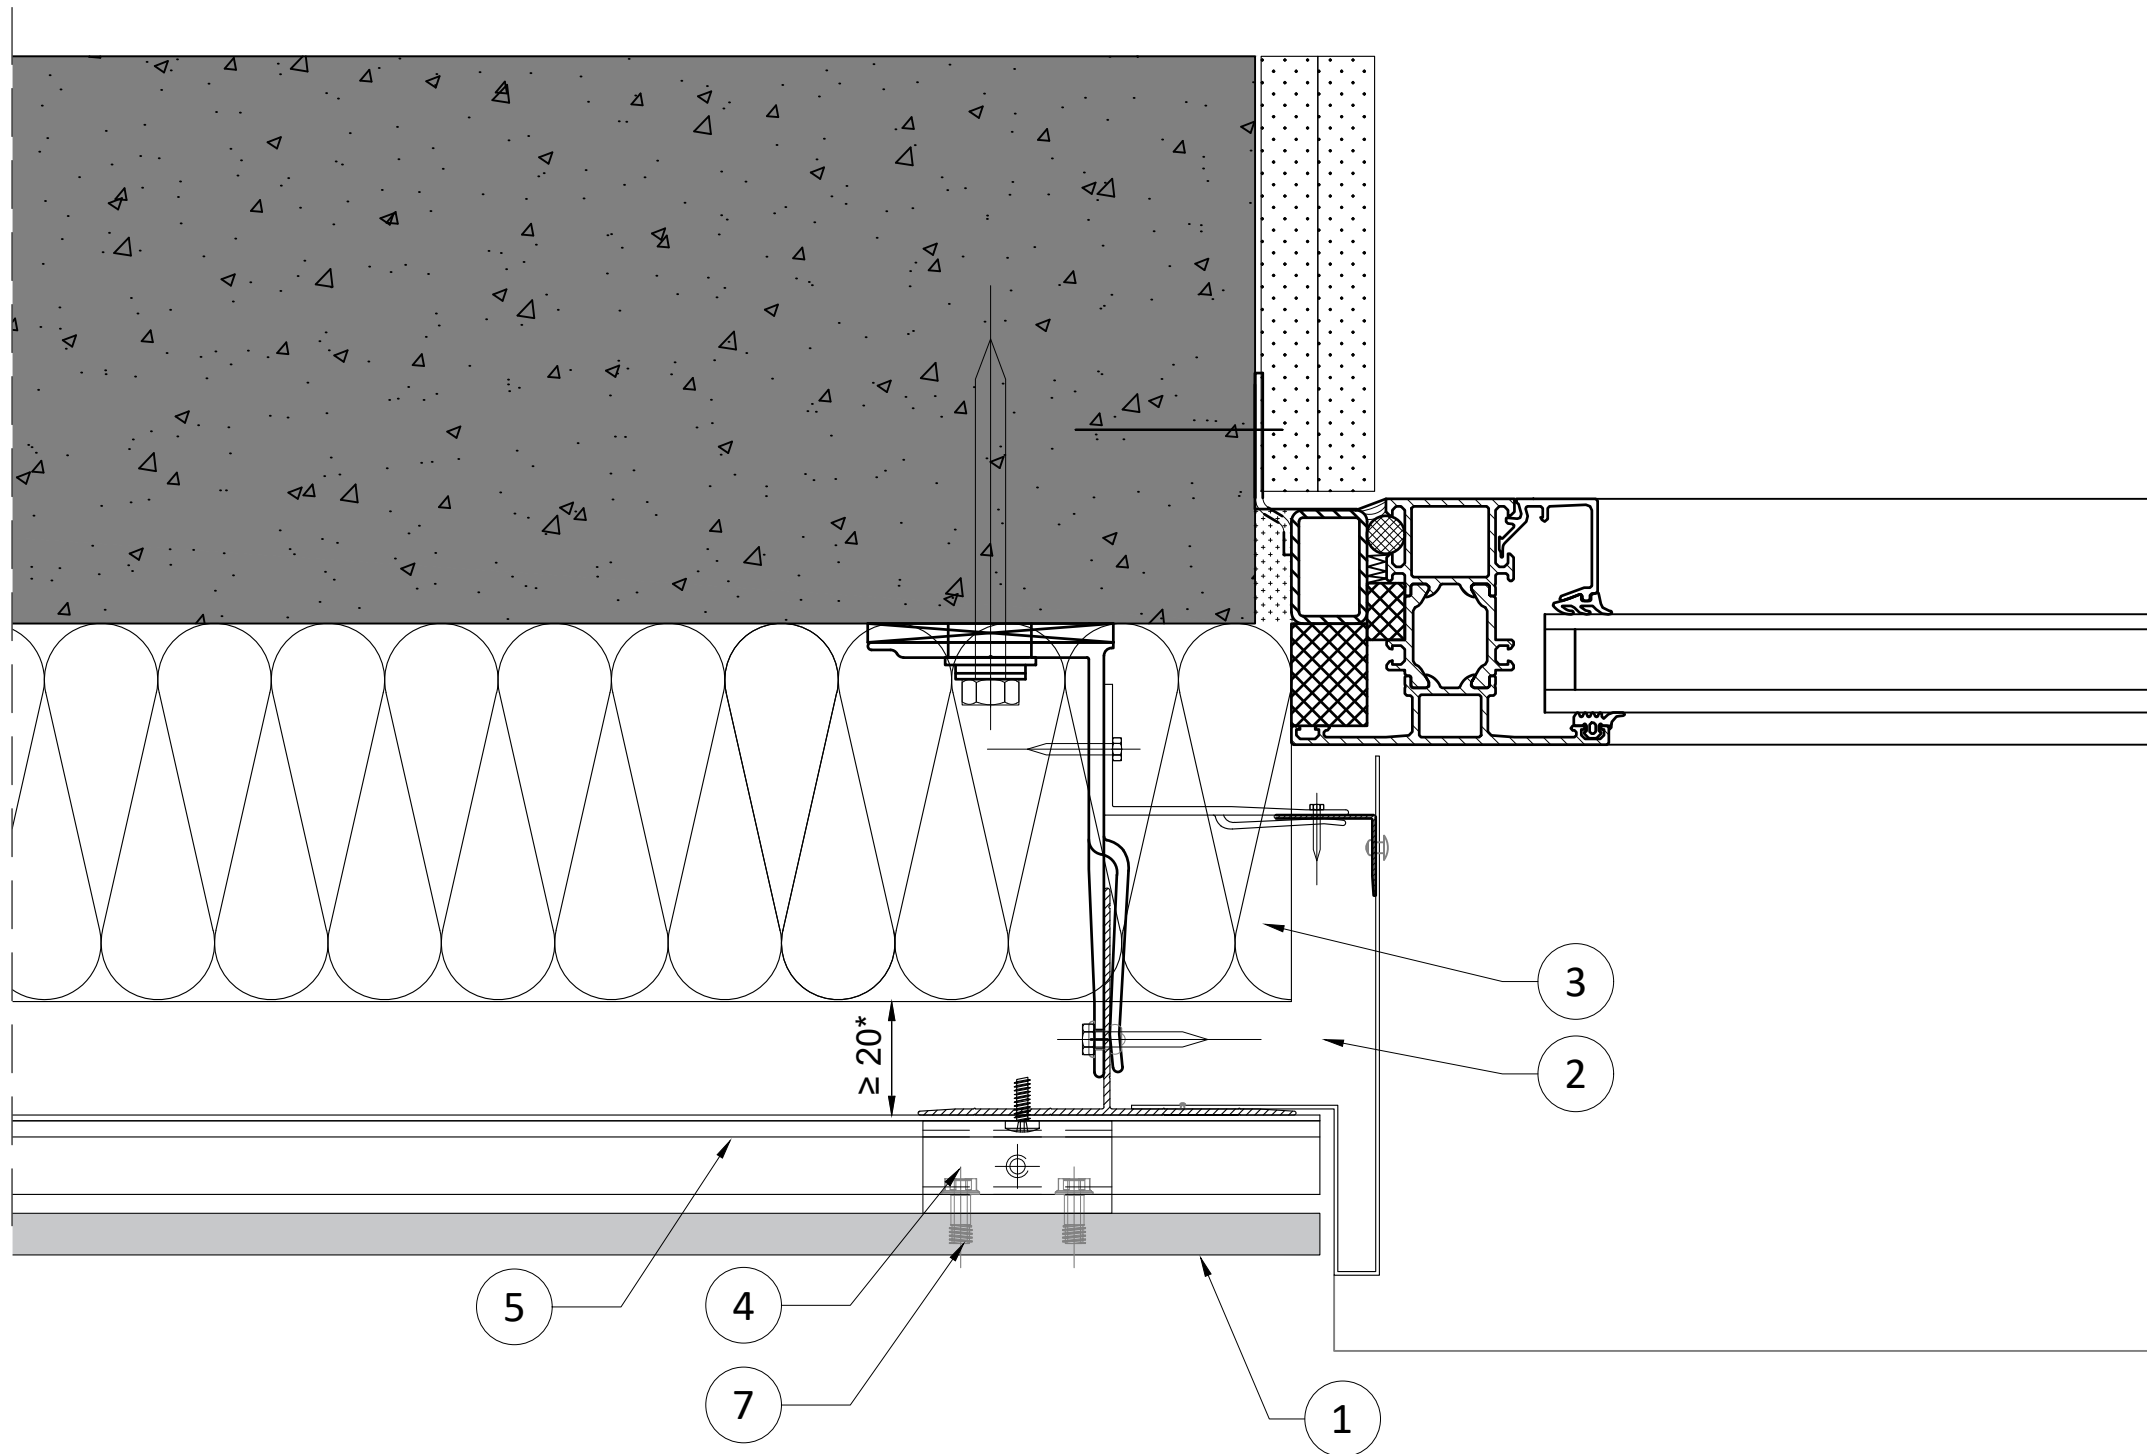

NUMBER
RP A2 11 MSF - H.02

BOARD - SUB-CONSTRUCTION
 Premium A2 11 mm - Mechanical Secret Fix

SECTION - DETAIL
 Horizontal section - Detail 02

DESCRIPTION
 Window junction


DATE - VERSION
 01.01.2025

SCALE - PAPER
 Scale 1:2 on A3 print

LANGUAGE
 All

PAGE - NUMBER
 Page 03/10



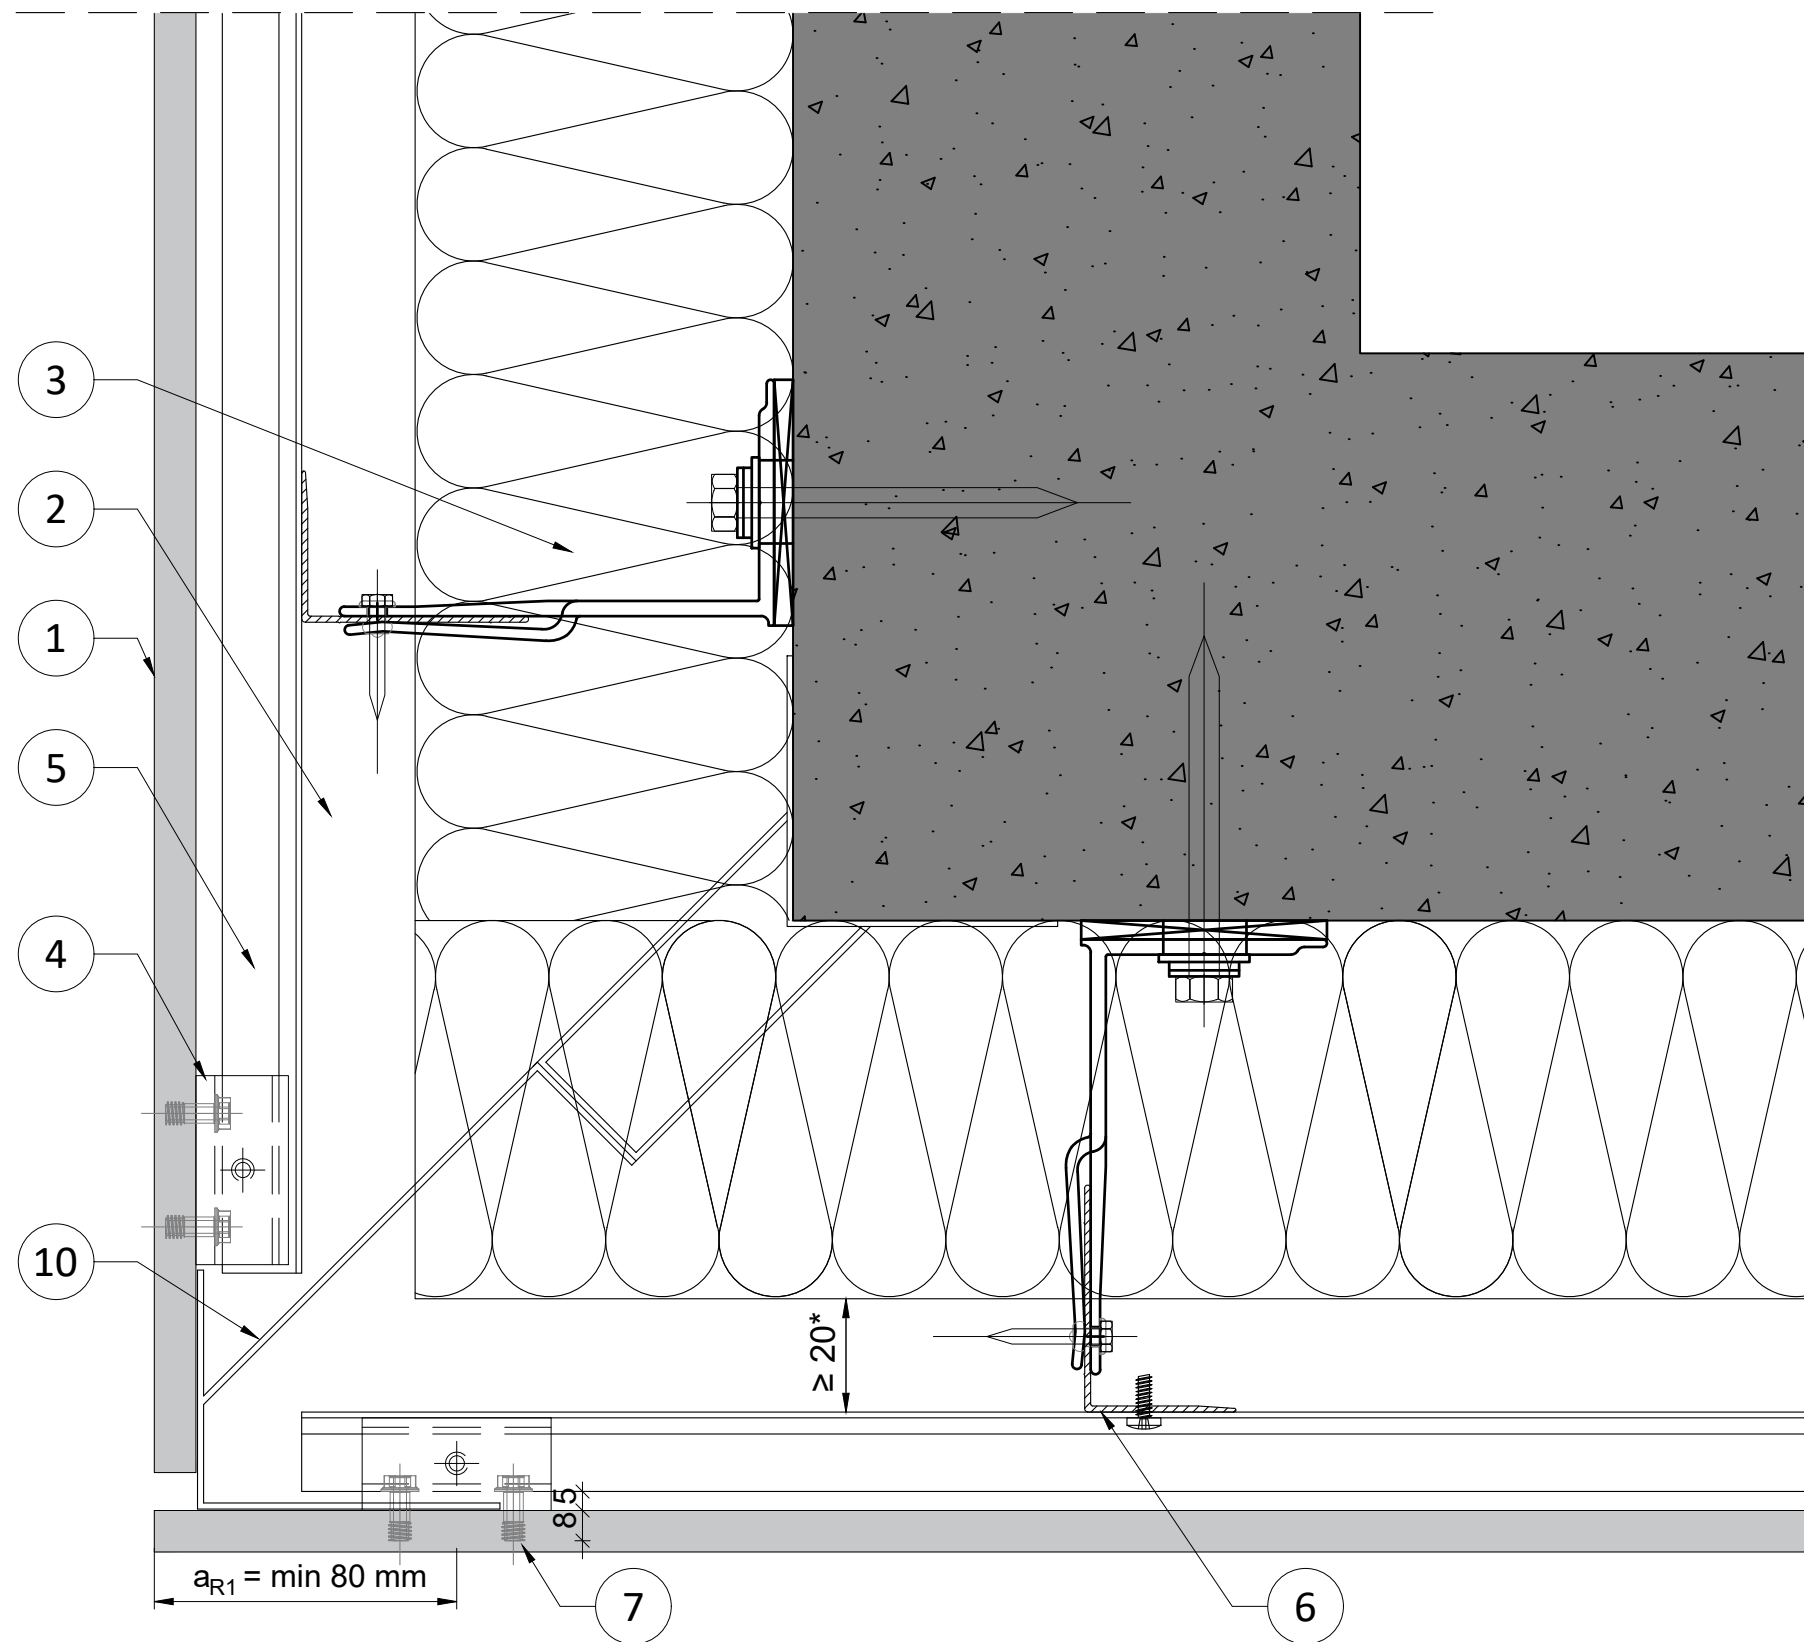

NUMBER
RP A2 11 MSF - H.03

BOARD - SUB-CONSTRUCTION
 Premium A2 11 mm - Mechanical Secret Fix

SECTION - DETAIL
 Horizontal section - Detail 03

DESCRIPTION
 Junction vertical joint


DATE - VERSION
 01.01.2025

SCALE - PAPER
 Scale 1:2 on A3 print

LANGUAGE
 All

PAGE - NUMBER
 Page 04/10



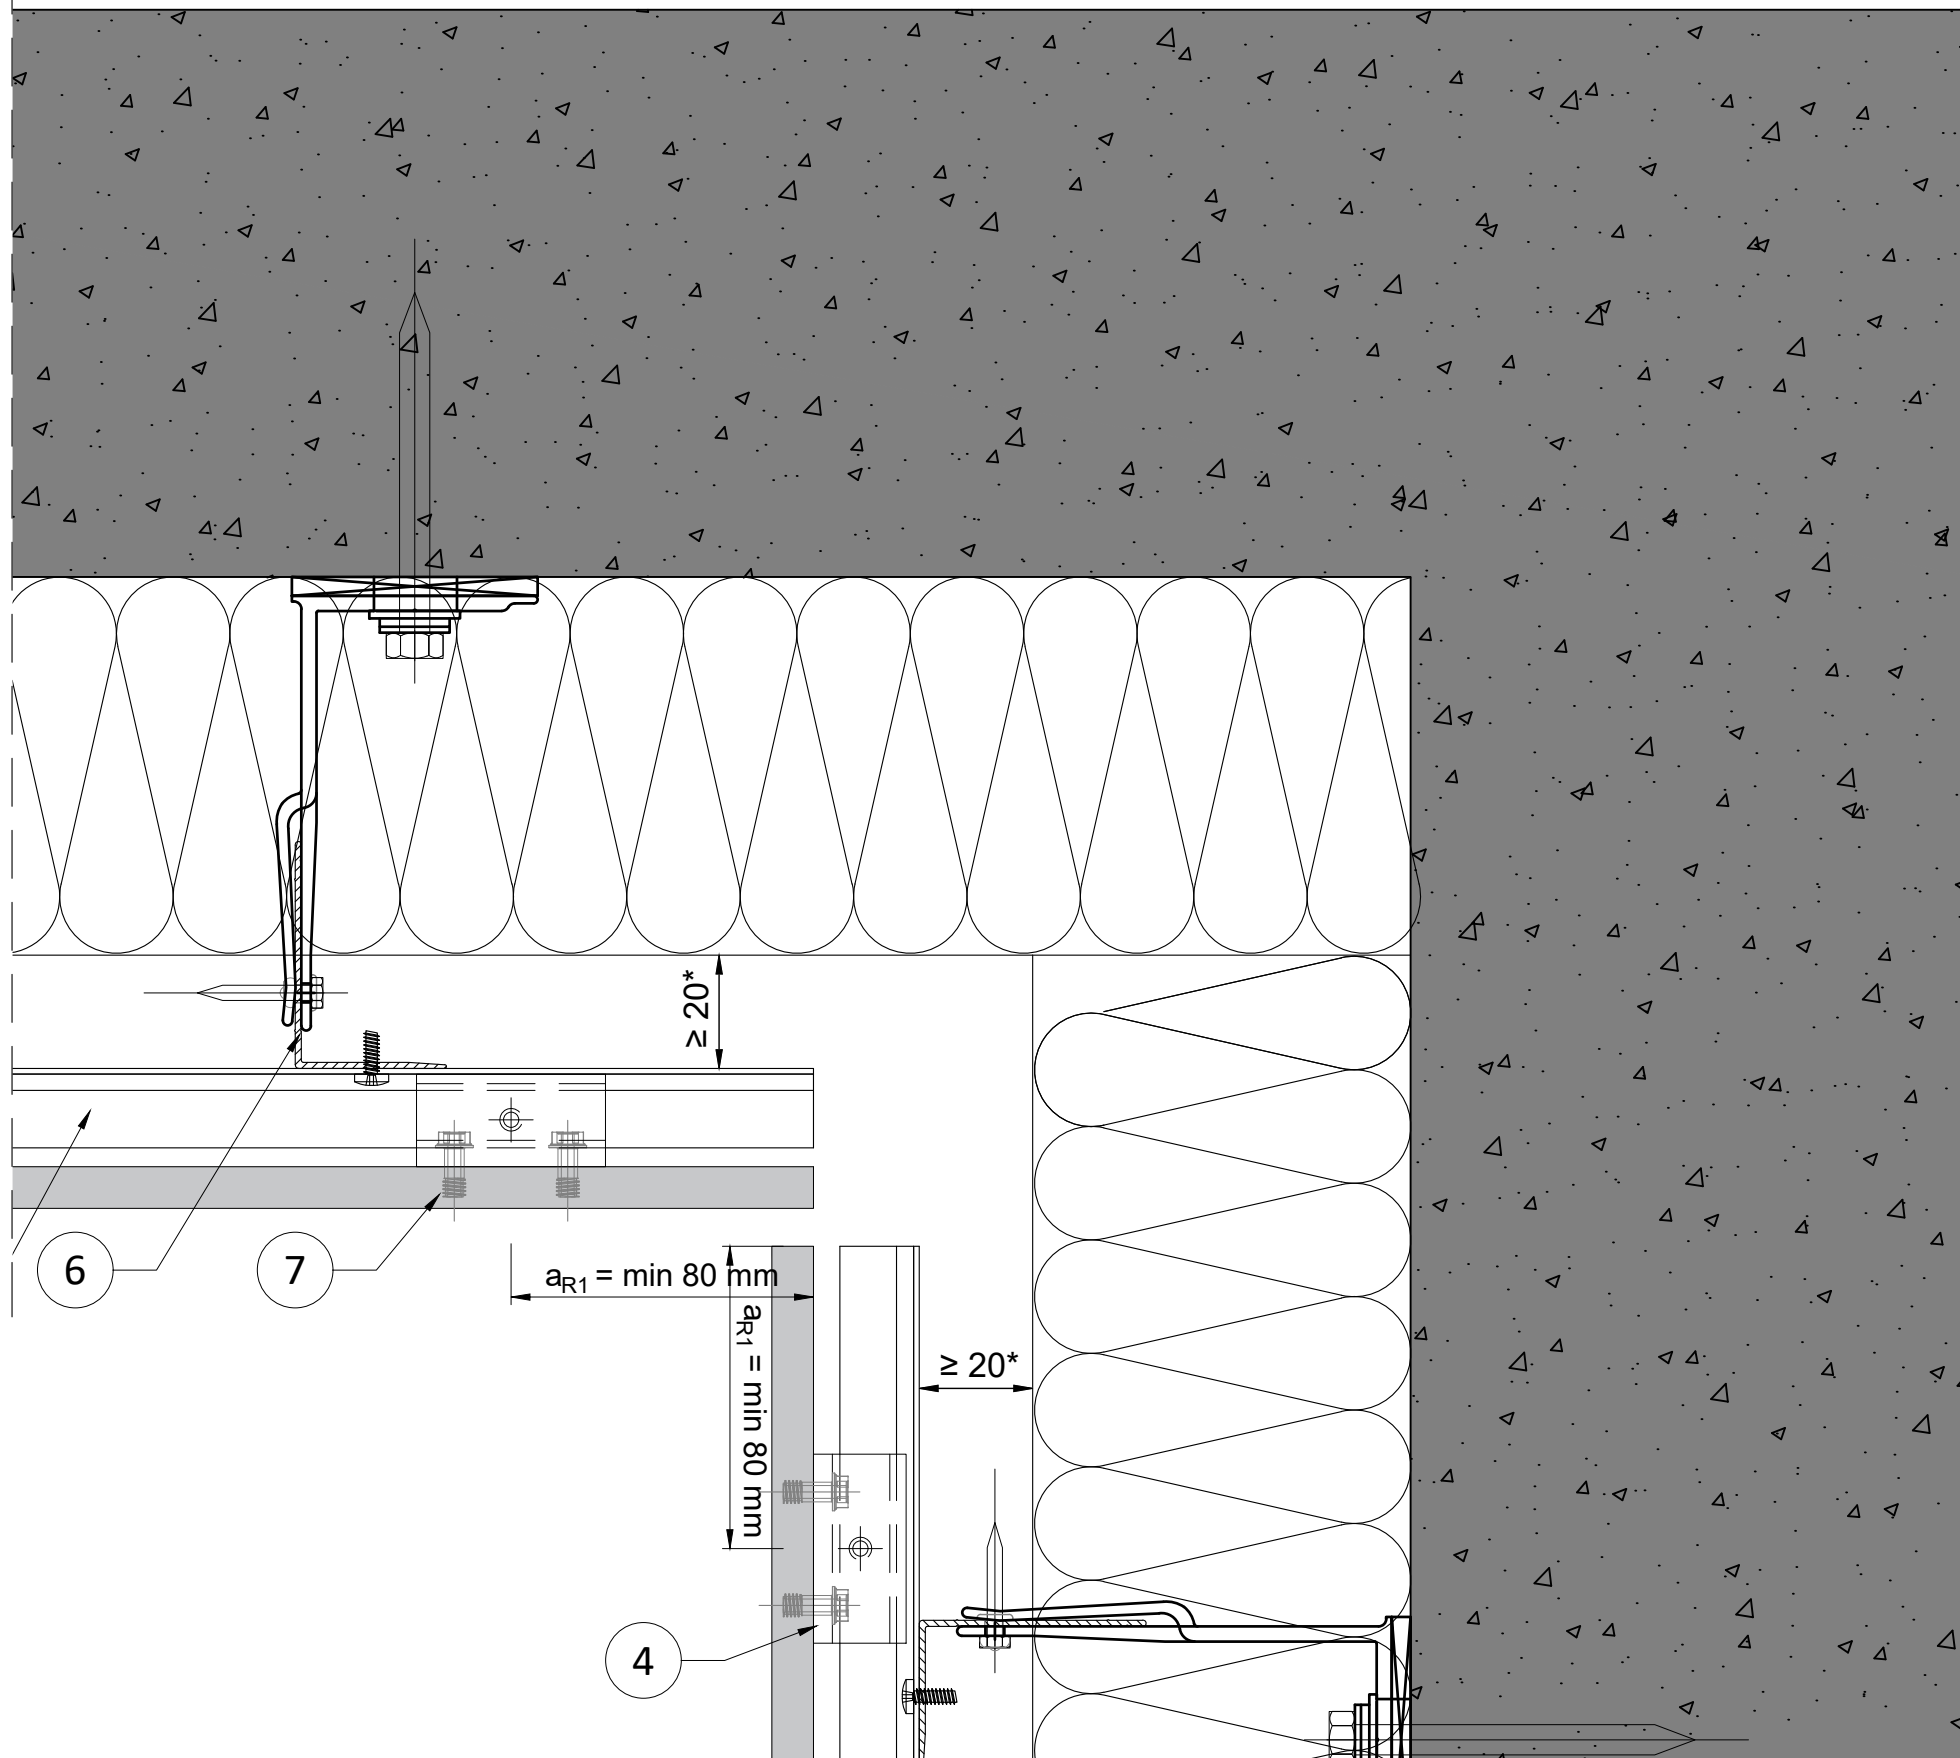


NUMBER
RP A2 11 MSF - H.04
 BOARD - SUB-CONSTRUCTION
Premium A2 11 mm - Mechanical Secret Fix
 SECTION - DETAIL
Horizontal section - Detail 04
 DESCRIPTION
Internal Corner

DATE - VERSION
 01.01.2025
 SCALE - PAPER
 Scale 1:2 on A3 print

LANGUAGE
 All
 PAGE - NUMBER
 Page 05/10



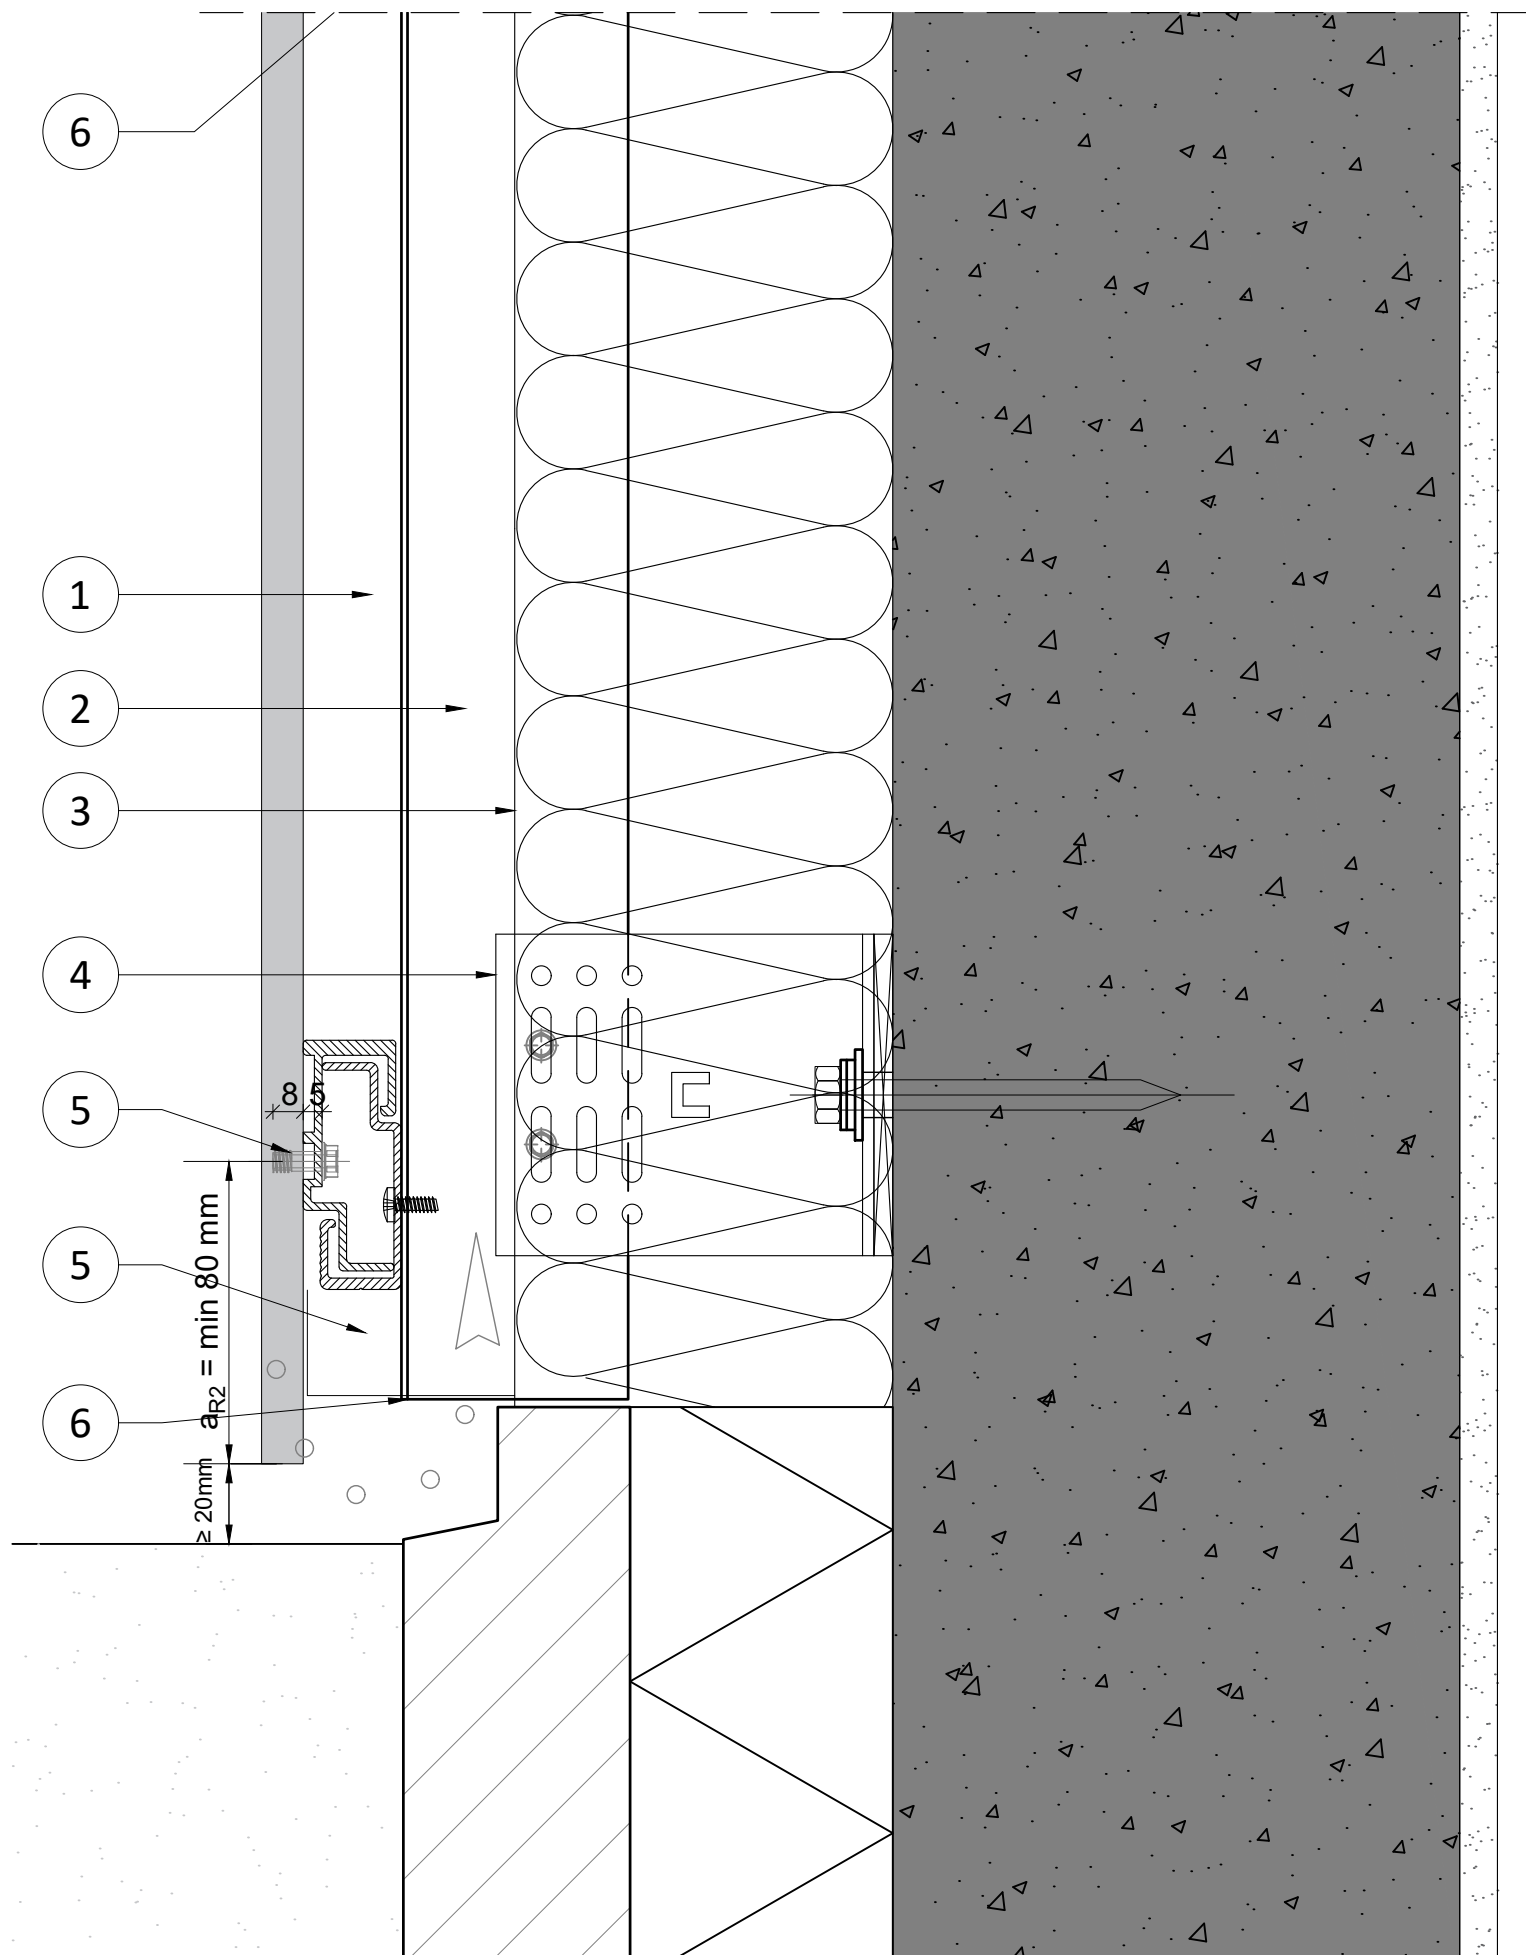

NUMBER
RP A2 11 MSF - V.01

BOARD - SUB-CONSTRUCTION
 Premium A2 11 mm - Mechanical Secret Fix

SECTION - DETAIL
 Vertical section - Detail 01

DESCRIPTION
 Junction vertical joint


DATE - VERSION
 01.01.2025

SCALE - PAPER
 Scale 1:2 on A3 print

LANGUAGE
 All

PAGE - NUMBER
 Page 06/10



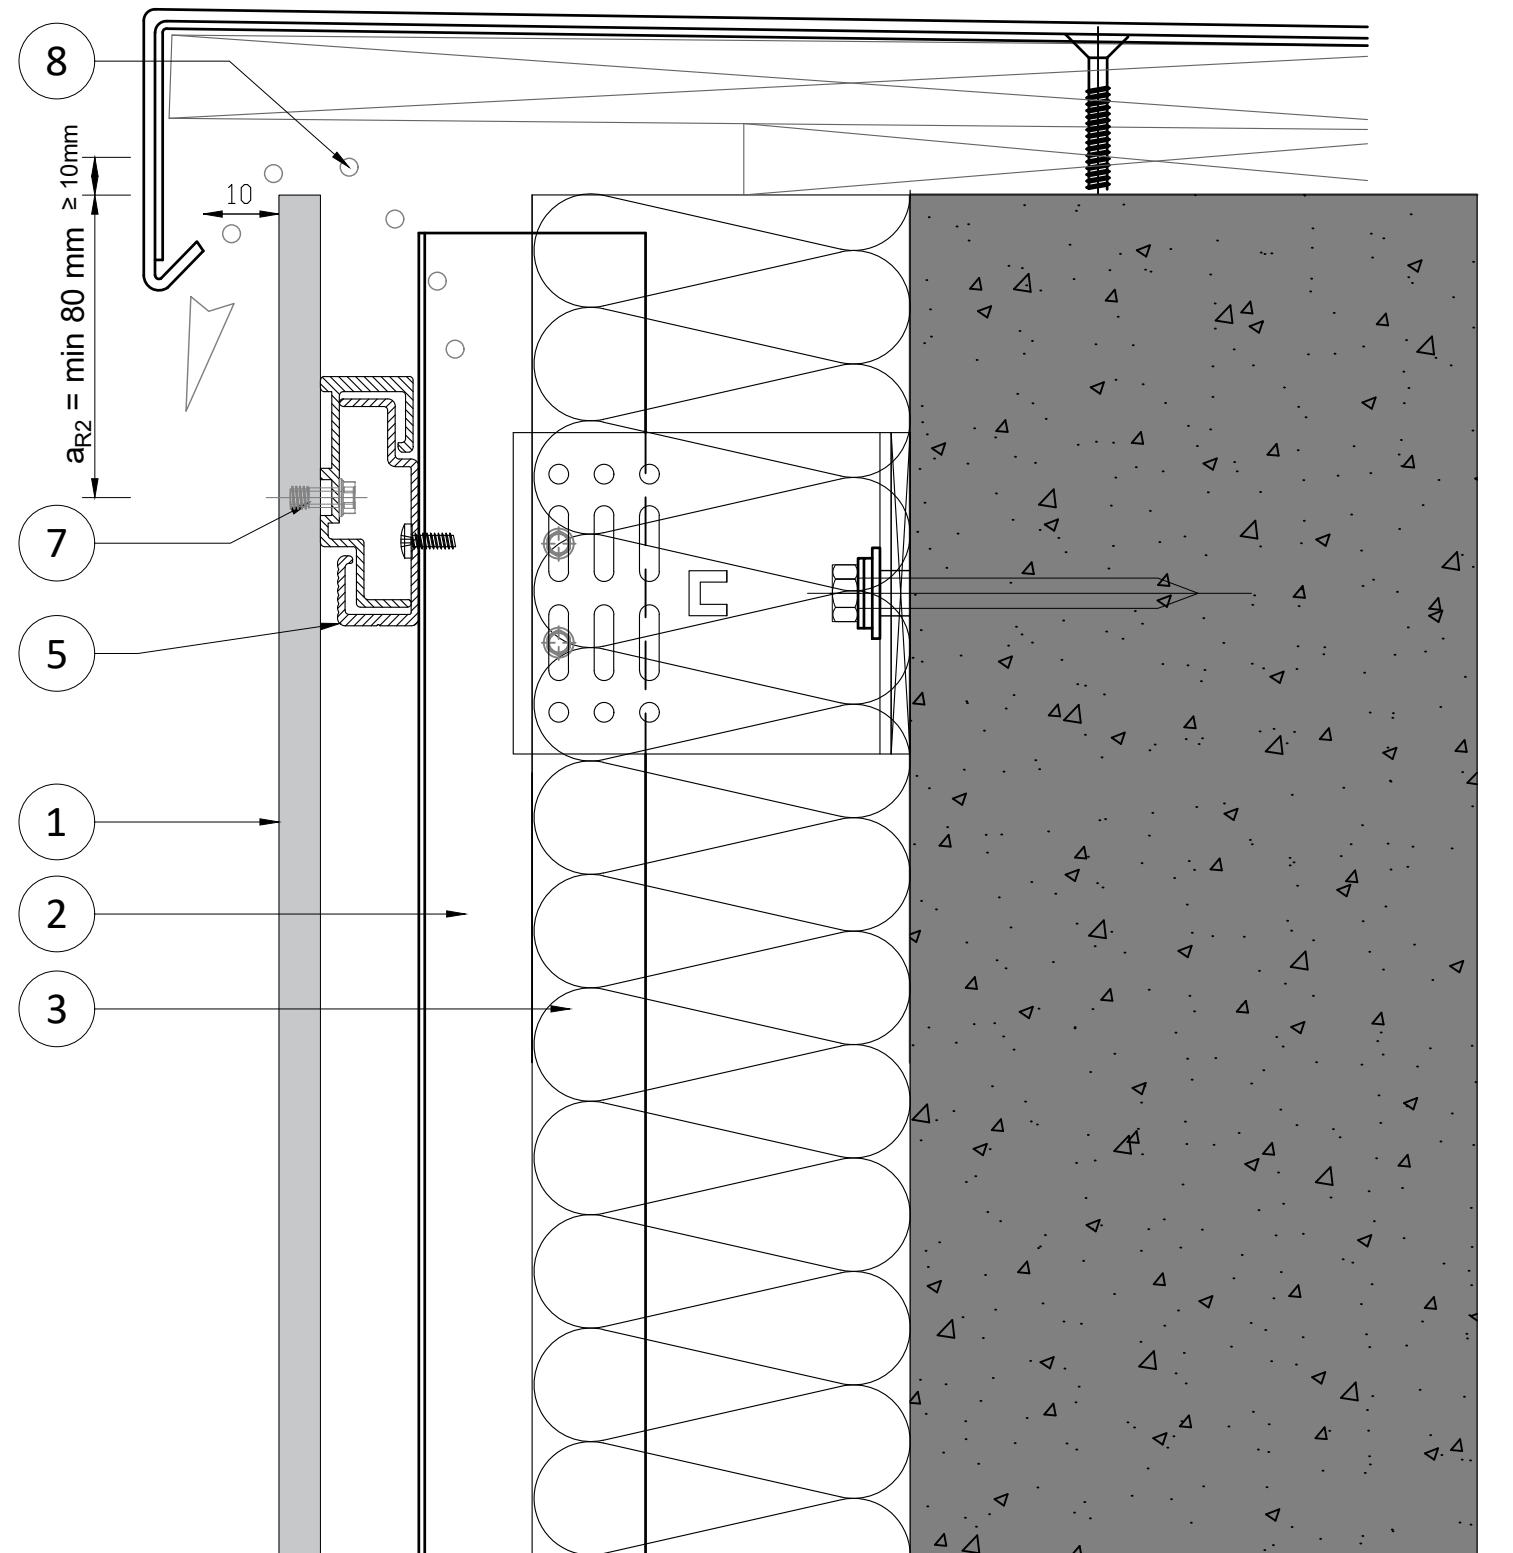

NUMBER
RP A2 11 MSF - V.02

BOARD - SUB-CONSTRUCTION
 Premium A2 11 mm - Mechanical Secret Fix

SECTION - DETAIL
 Vertical section - Detail 04

DESCRIPTION
 Roof trim - parapet


DATE - VERSION
 01.01.2025

SCALE - PAPER
 Scale 1:2 on A3 print

LANGUAGE
 All

PAGE - NUMBER
 Page 07/10



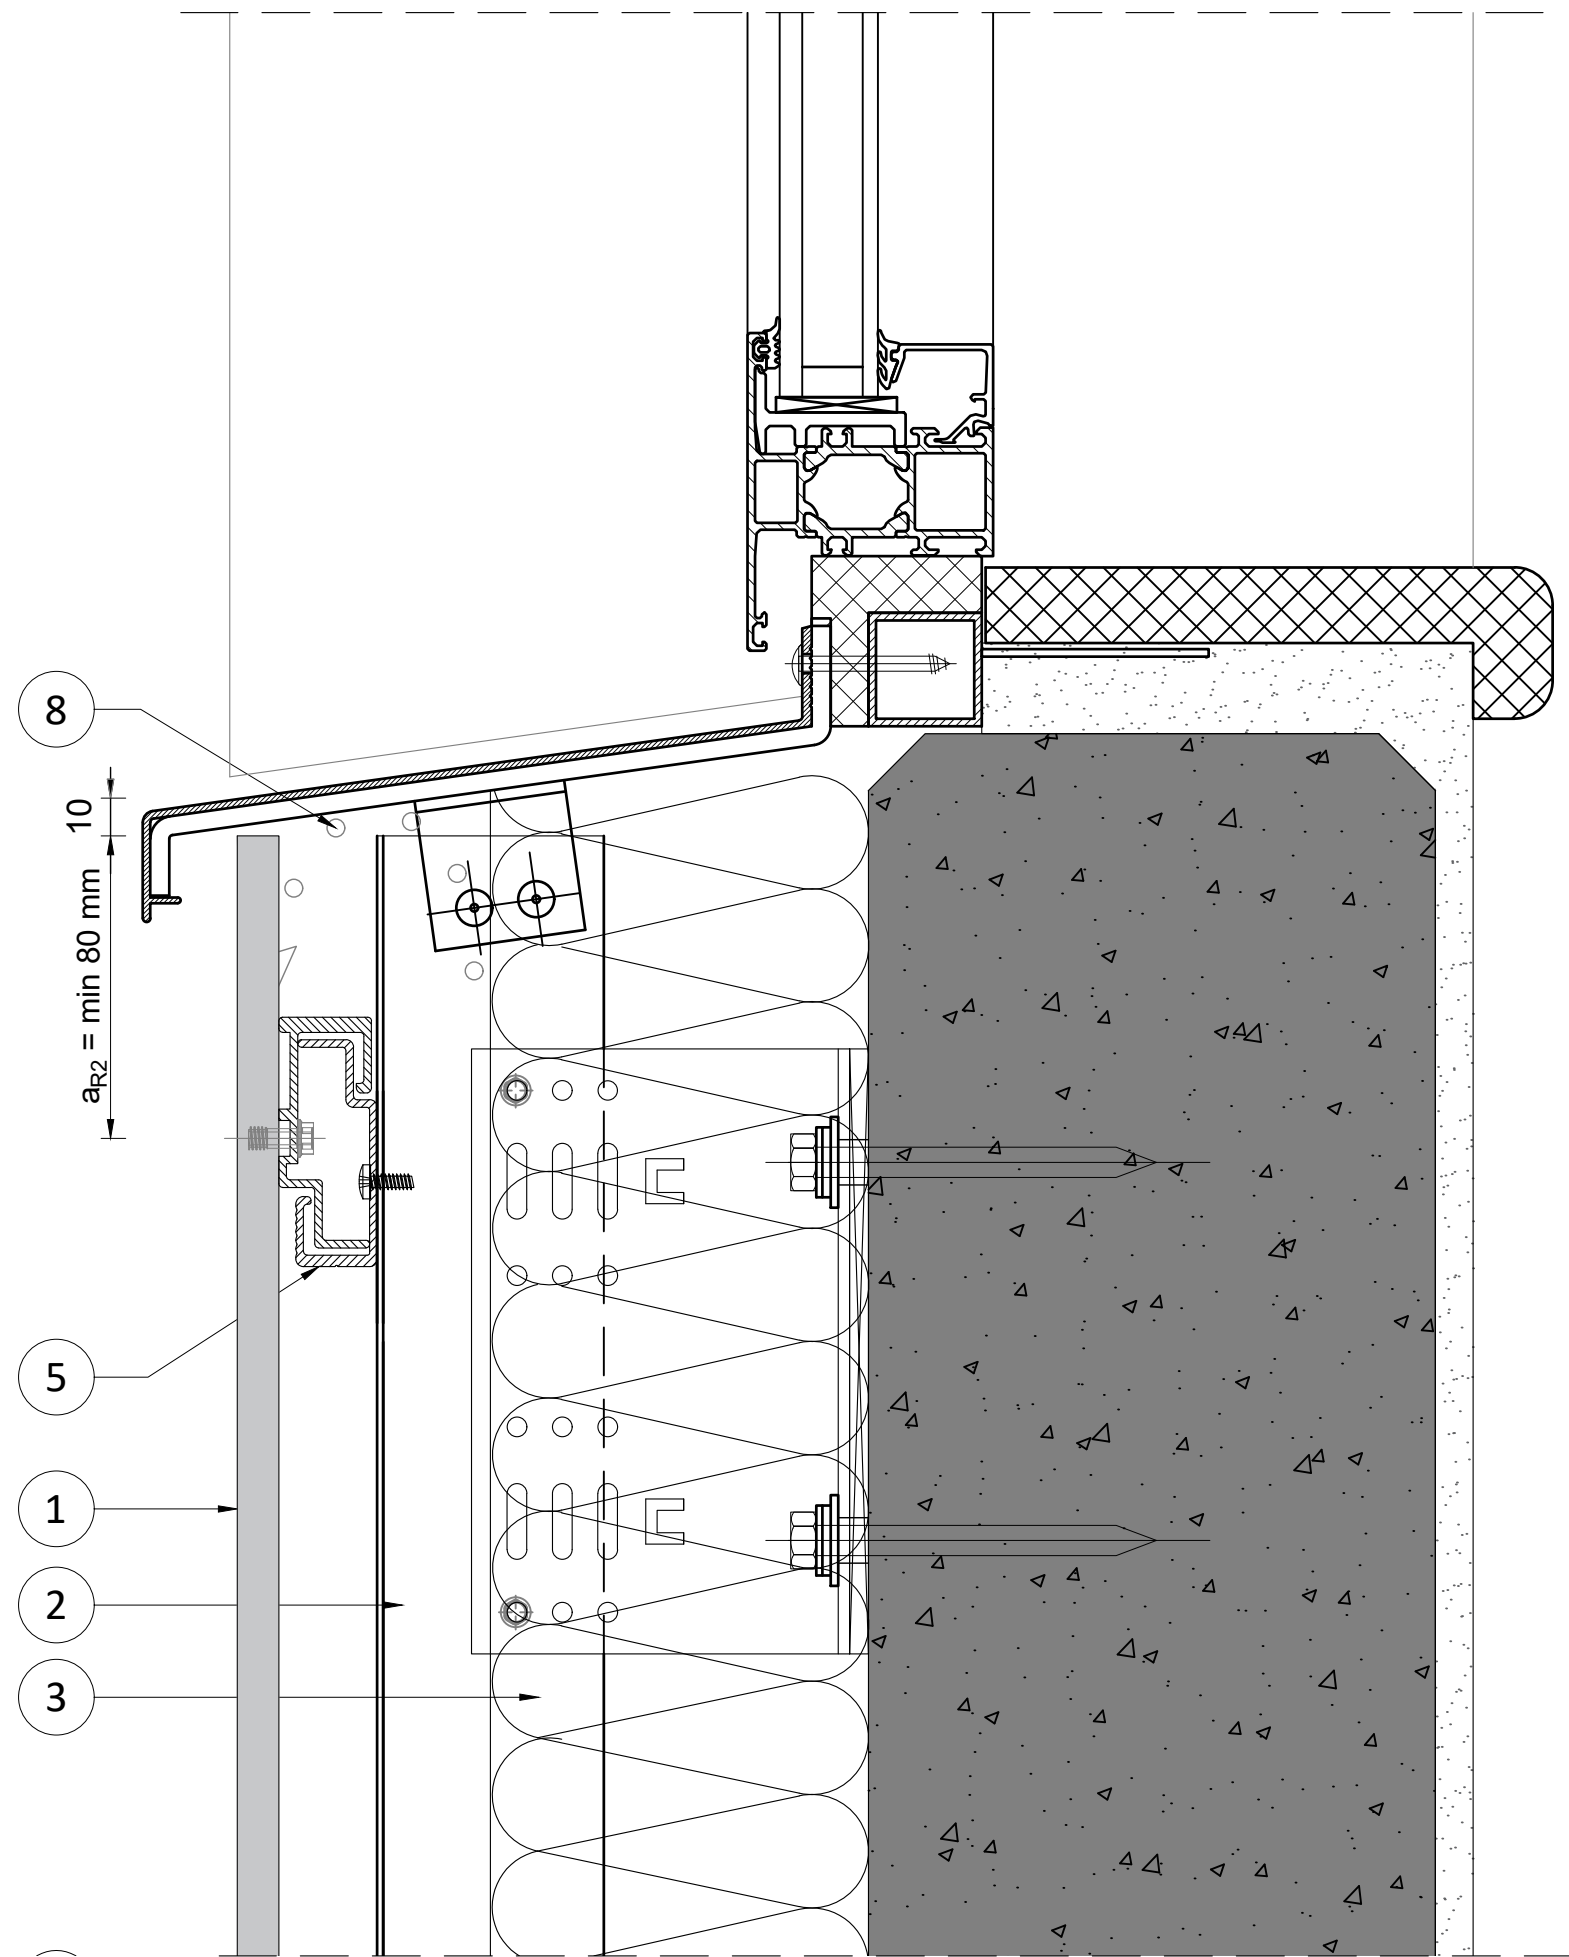

NUMBER
RP A2 11 MSF - V.03

BOARD - SUB-CONSTRUCTION
 Premium A2 11 mm - Mechanical Secret Fix

SECTION - DETAIL
 Vertical section - Detail 03

DESCRIPTION
 Junction window-sill


DATE - VERSION
 01.01.2025

SCALE - PAPER
 Scale 1:2 on A3 print

LANGUAGE
 All

PAGE - NUMBER
 Page 08/10



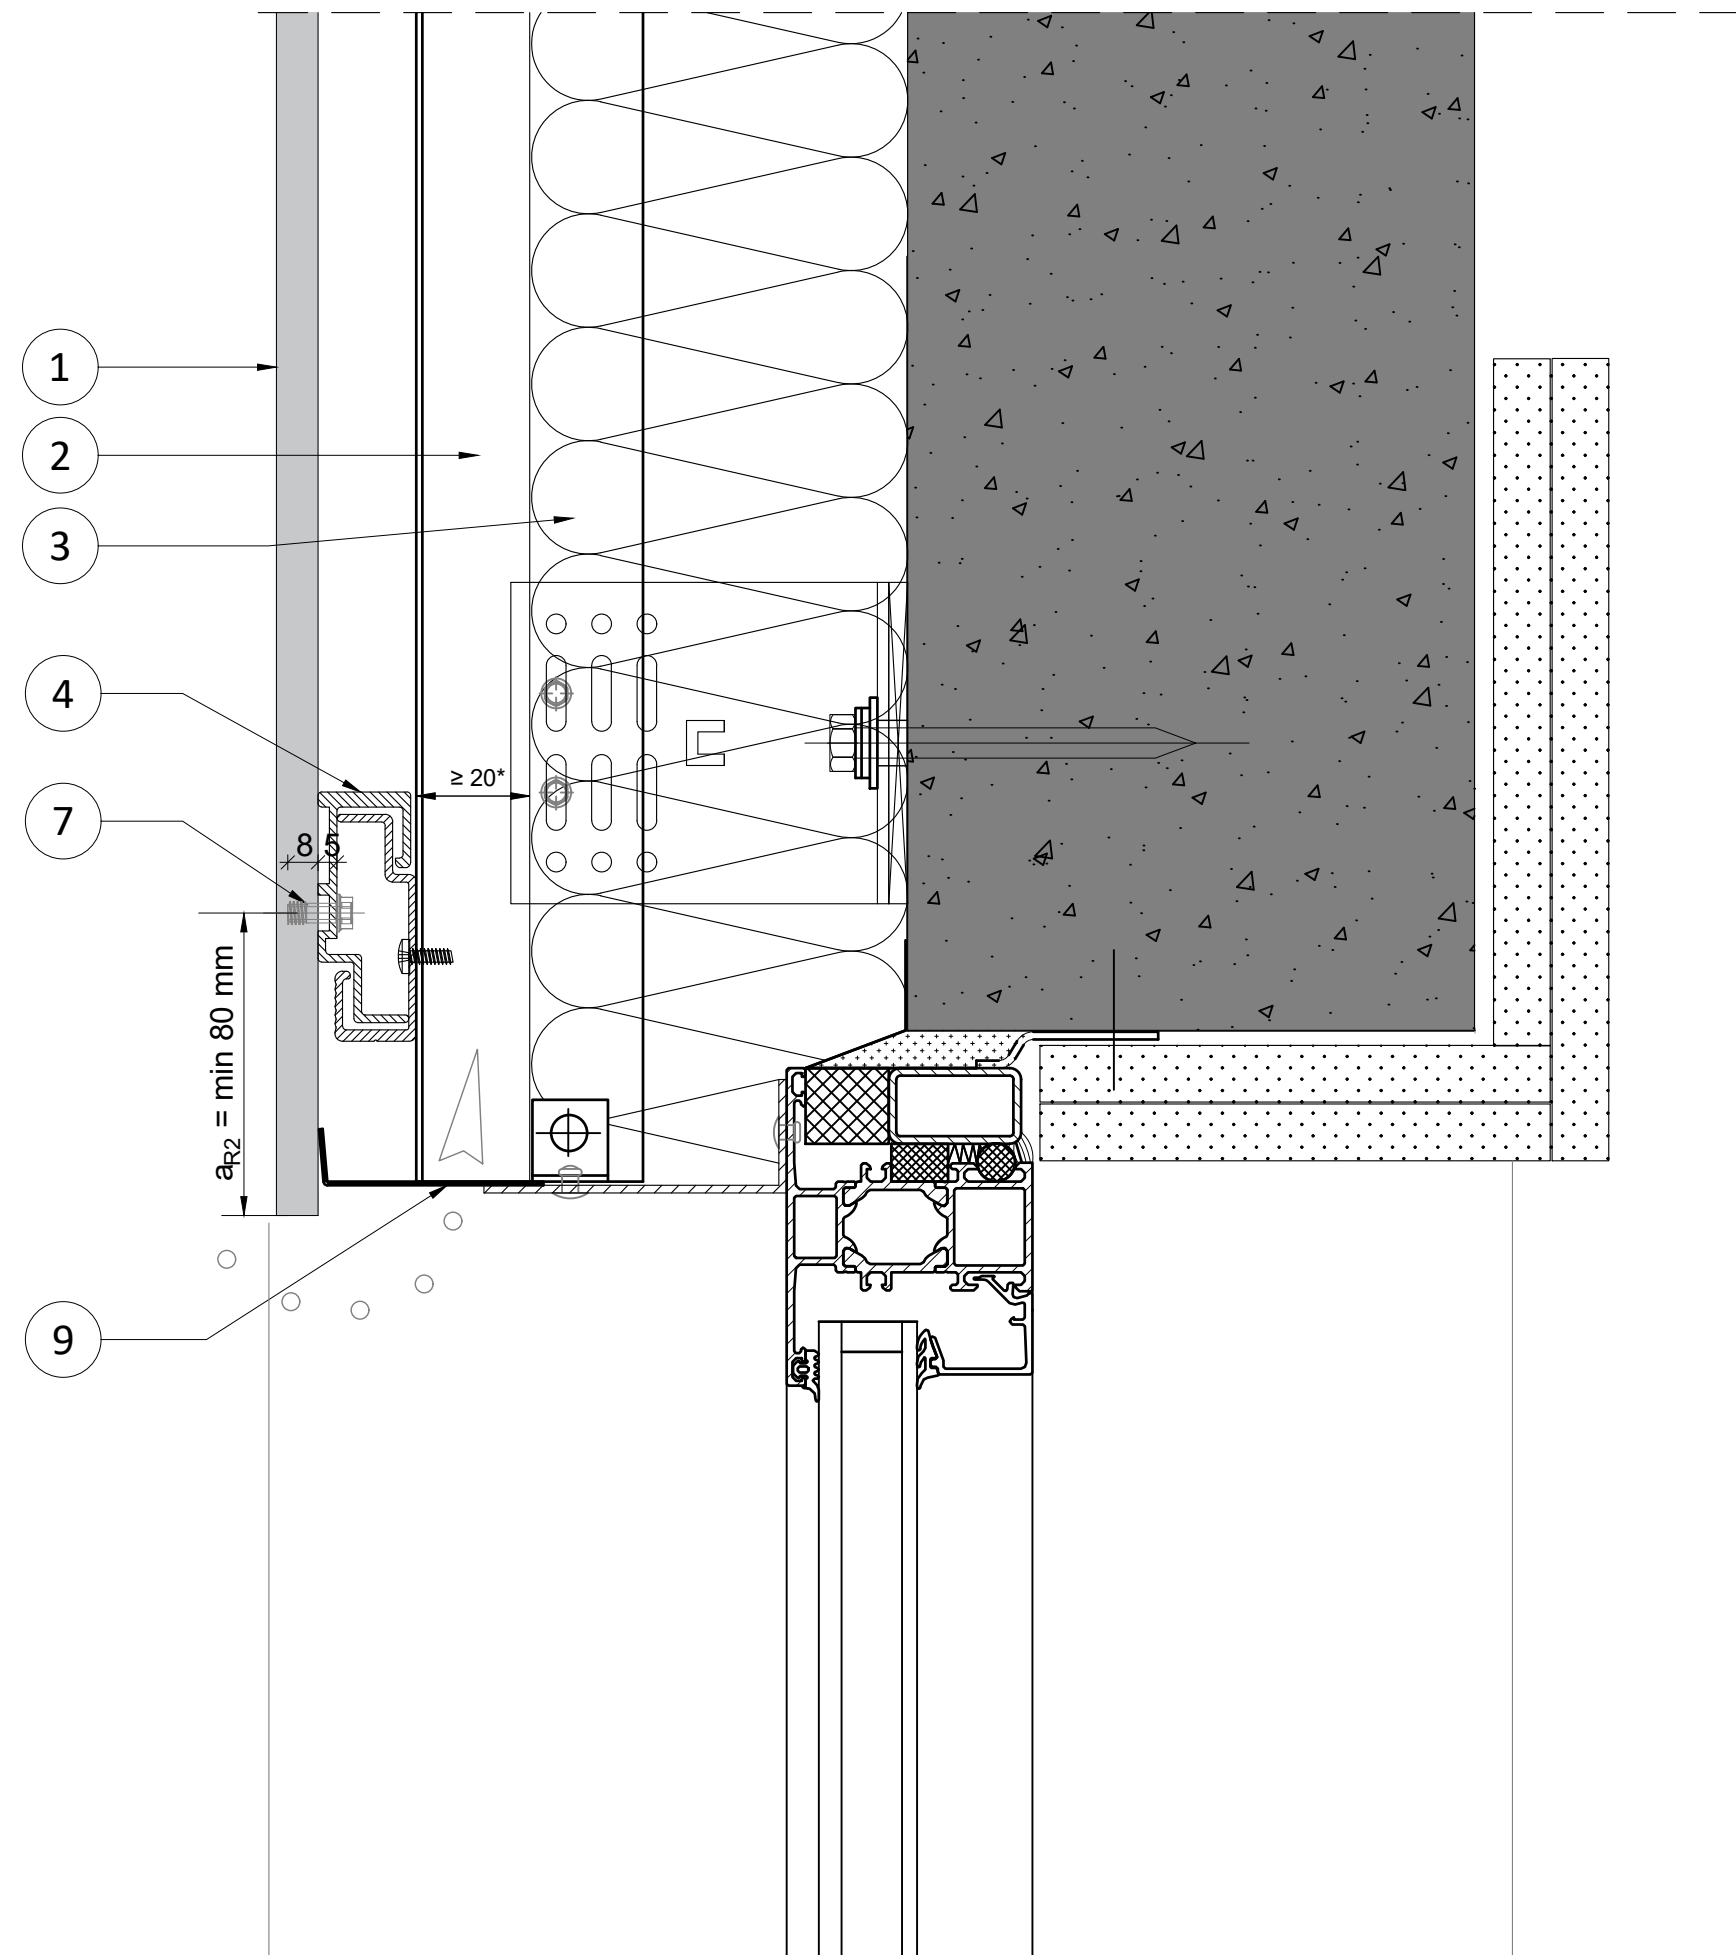

NUMBER
RP A2 11 MSF - V.04

BOARD - SUB-CONSTRUCTION
Premium A2 11 mm - Mechanical Secret Fix

SECTION - DETAIL
Vertical section - Detail 04

DESCRIPTION
Junction window header

DATE - VERSION
 01.01.2025

SCALE - PAPER
 Scale 1:2 on A3 print

LANGUAGE
 All

PAGE - NUMBER
 Page 09/10



EN	NL	DE	FR	PL	
1	Rockpanel Premium A2	Rockpanel Premium A2	Rockpanel Premium A2	Rockpanel Premium A2	
2	Air cavity	Luchtspouw	Hinterlüftungsraum	Lame d'air	Szczelina wentylacja
3	Insulation (ROCKWOOL)	Steenwolisolatie (ROCKWOOL)	Dämmung (ROCKWOOL)	Isolation (ROCKWOOL)	Izolacja (ROCKWOOL)
4	Secret fixing clip (C-Clip)	Plaathaak (C-clip)	Agraffe (C-clip)	Clips de fixations aveugles	Klips mocowania ukrytego
5	Horizontal profile / rail	Horizontaal profiel / rail	Horizontales Profil	Profil horizontal	Profil poziomy
6	Vertical profile / rail	Verticaal profiel / rail	Vertikales Profil	Profil vertical	Profil pionowy
7	TU-S Blind fastener (undercut anchor)	TU-S blind bevestigiger (anker)	TU-S Blindbefestigung	Fixation aveugle TU-S	TU-S Mocowanie ukryte (kotwa)
8	Ventilation	Ventilatie	Belüftung	Ventilation	Wentylacja
9	Anti-Insect mesh	Ventilatieprofiel (anti-insect)	Lüftungsprofil	Grille anti-rongeur	Siatka zabezpieczająca przed owadami
10	Cavity closure	Spouw in uitwendige hoek dichtgezet	Hohlraumverschluss	Profil vertical de compartimentage	Rockpanel Durable 8 mm z powłoką m

EN	DK	NO	SE	FI	
1	Rockpanel Premium A2	Rockpanel Premium A2	Rockpanel Premium A2	Rockpanel Premium A2	
2	Air cavity	Ventilation	Luft hulrom	Luftspalt	Tuuletusväli
3	Insulation (ROCKWOOL)	Isolering (ROCKWOOL)	Isolasjon (ROCKWOOL)	Isolering (ROCKWOOL)	Eriste (ROCKWOOL)
4	Secret fixing clip (C-Clip)	Skjult fastgørelsesclips	Skjult feste klips (C-clip)	Clip för dold infästning (C-Clip)	Piilokiinnitysriipustin (C-Clip)
5	Horizontal profile / rail	Vandret profil	Horisontal profil / skinne	Horisontell profil / skena	Vaakaranka
6	Vertical profile / rail	Lodret profil	Vertikal profil / skinne	Vertikal profil / skena	Pystyranka
7	TU-S Blind fastener (undercut anchor)	TU-S skjult fastgørelse (anker)	TU-S blindfeste (ankre)	TU-S infästning (popskruv)	TU-S piilokiinnike (piilokiinnitysniitti)
8	Ventilation	Ventilation	Ventilasjon	Ventilation	Tuuletus
9	Anti-Insect mesh	Insektnett	Insektsnett	Insektsskydd	Hyönteisverkko
10	Cavity closure	Tætningsliste	Tetteliste	Stängning av hålrum	Tuuletusvälin jakaja

NUMBER

RP A2 11 - MSF

BOARD - SUB-CONSTRUCTION

Premium A2 11 mm - MSF

SECTION - DETAIL

Descriptions and translations

